


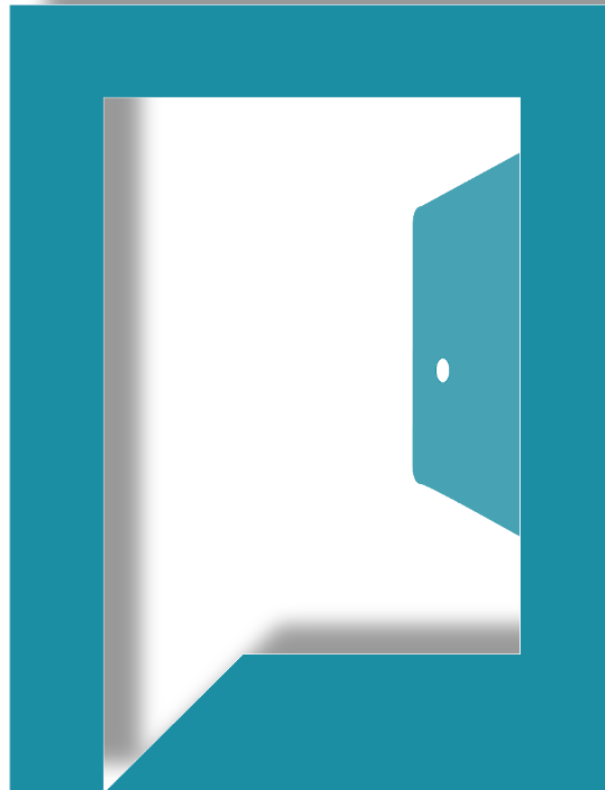

PC designs

Architecture & Construction

ARCHITECTURE | CONSTRUCTION | INTERIOR | MANAGEMENT | BIM | DIGITAL

www.pcdesigns.in | 7845223384

01 PHOENIX VILLA

CLIENT - SHANTHI
TYPOLOGY - RESIDENCE
LOCATION - THENI
SCOPE - DESIGN & CONSTRUCTION
AREA - 1200 Sqft




PC designs
Architecture & Construction





PC designs
rchitecture & Construction

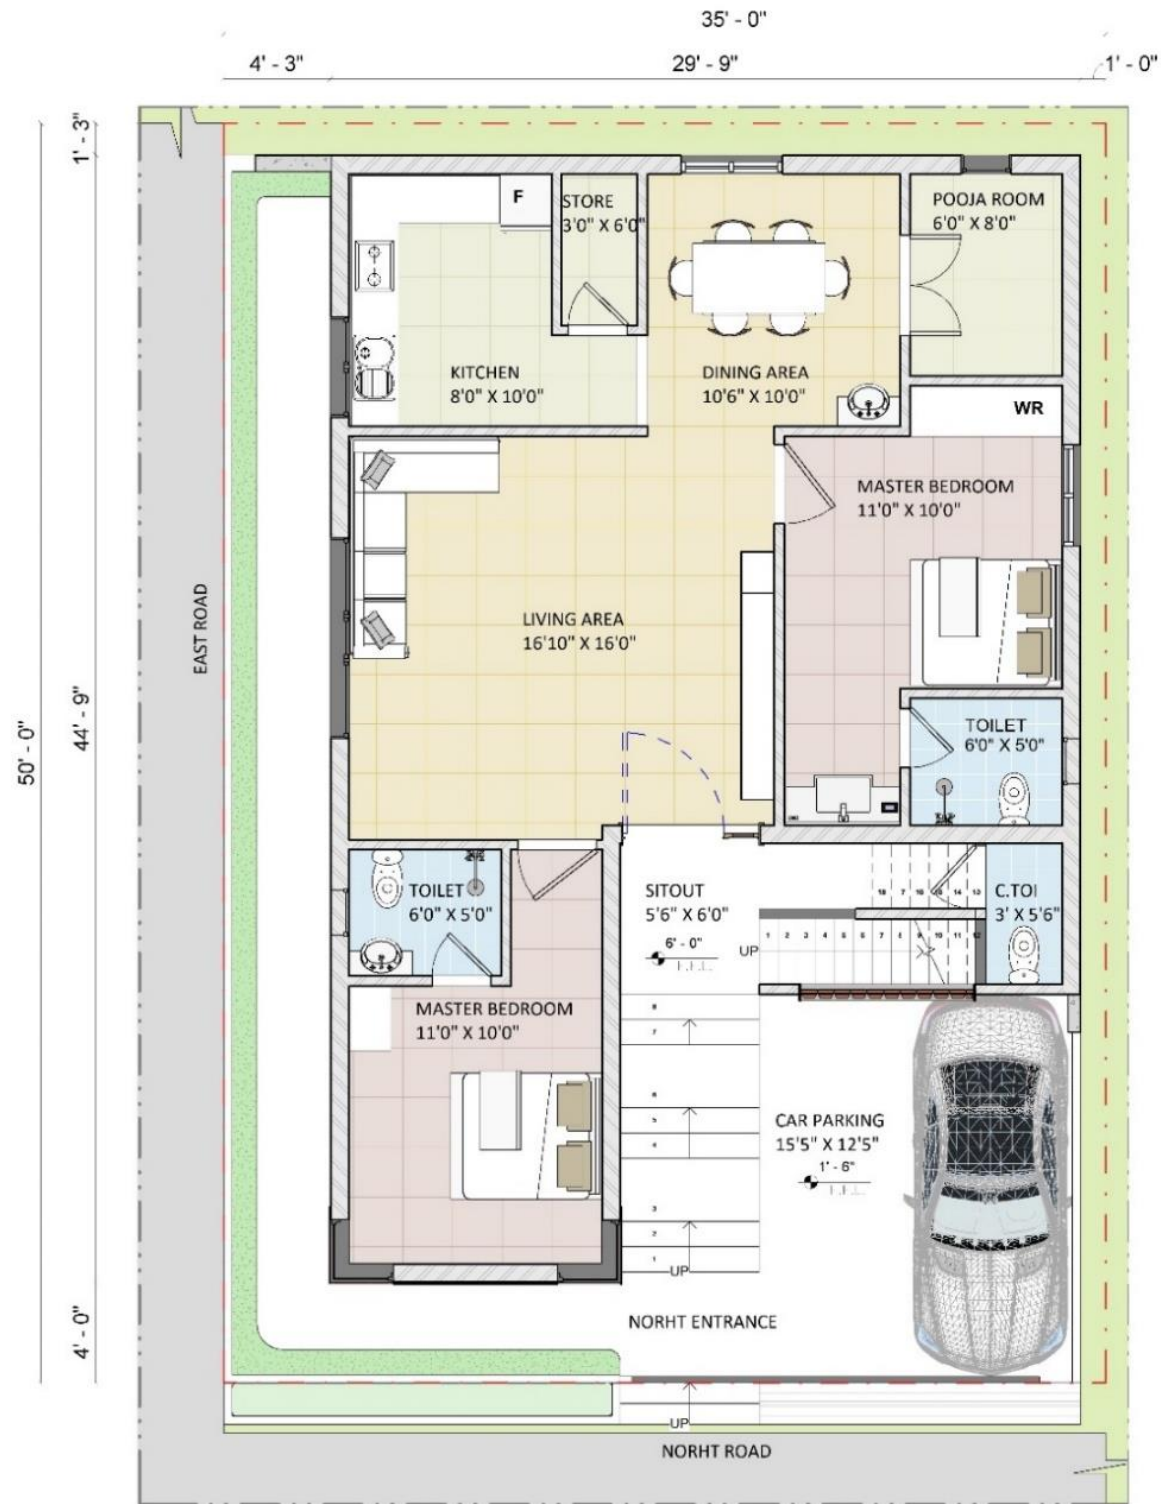

Sheet Title : SCHEME LAYOUT
Client Name : VS CHANDRAN VILLA @ Theni



Project Number : 028
Date : 05 / 07 / 2022
Scale : 1 : 50


Sheet No : 01
Detailed by : PC
Approved by : Ar Pravin Chandran

Revision no :
Revision Date :
Copyright

PC designs
Copyright



Architects & Builders
Bangalore | Chennai | Theni
Mob: 7845223384
www.pcdesigns.in

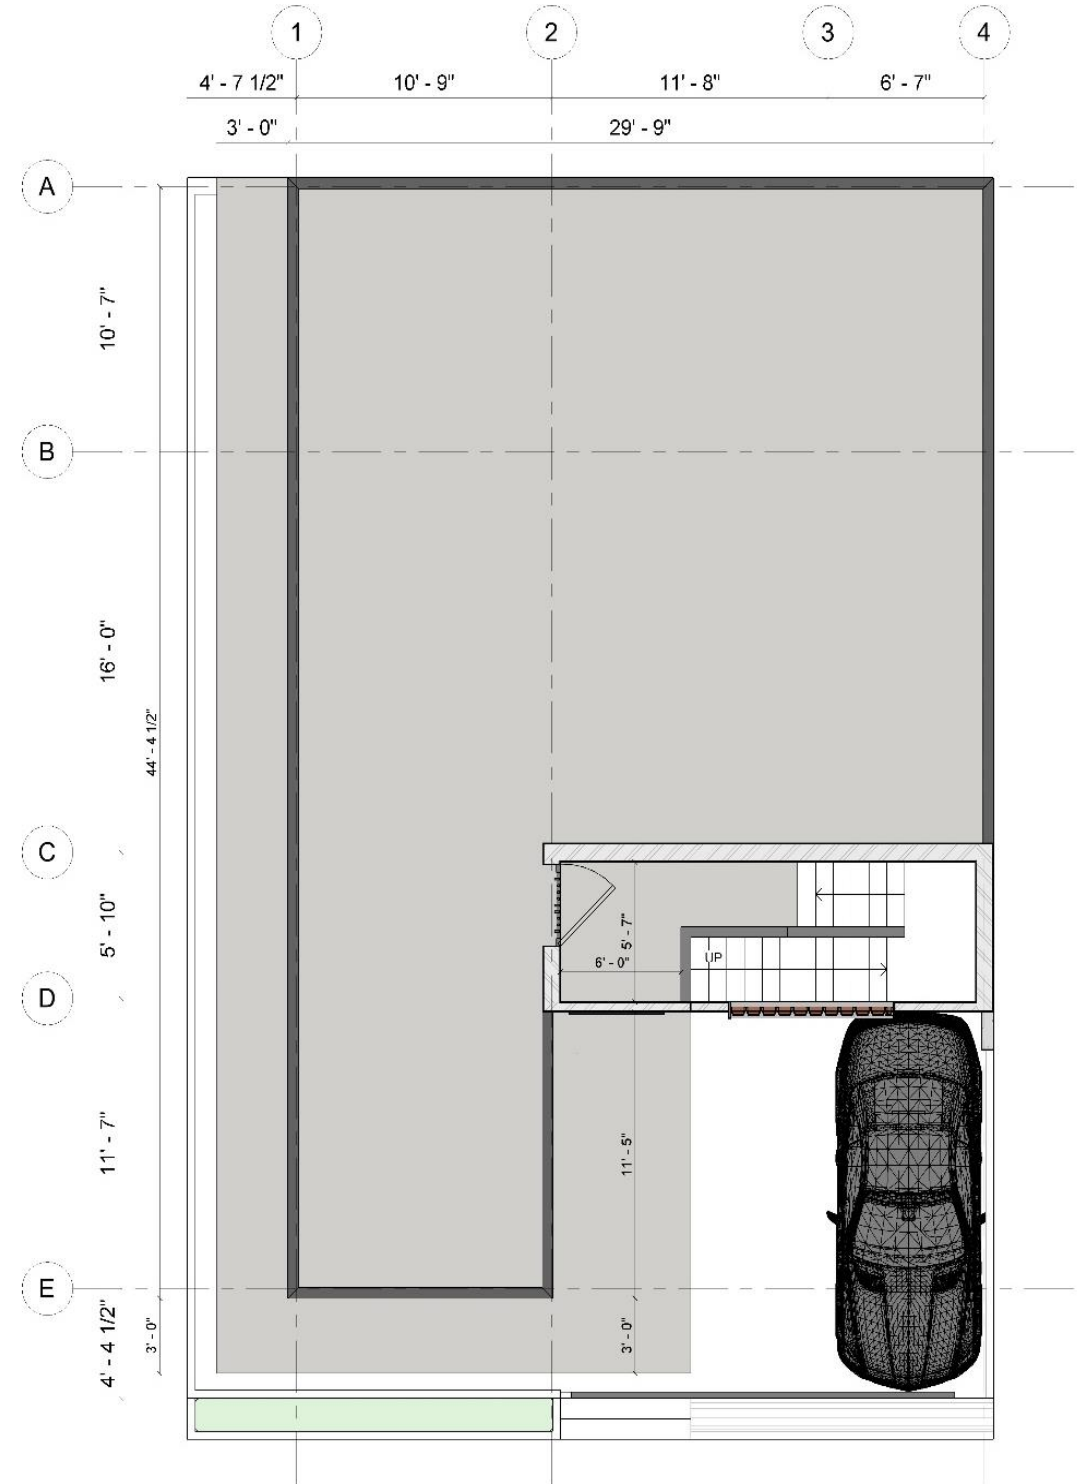

Sheet Title : FIRST FLOOR PLAN
Client Name : VS CHANDRAN VILLA @ Theni



Project Number : 028
Date : 05 / 07 / 2022
Scale : 1 : 50

Sheet No : 03
Detailed by : Ar.Abarazithan
Approved by : Ar.Delvi

Revision no :
Revision Date :
Copyright


PC designs
Copyright



Architects & Builders
Bangalore | Chennai |
Mob: 7845223384
www.pcdesigns.in



PC designs
rchitecture & Construction

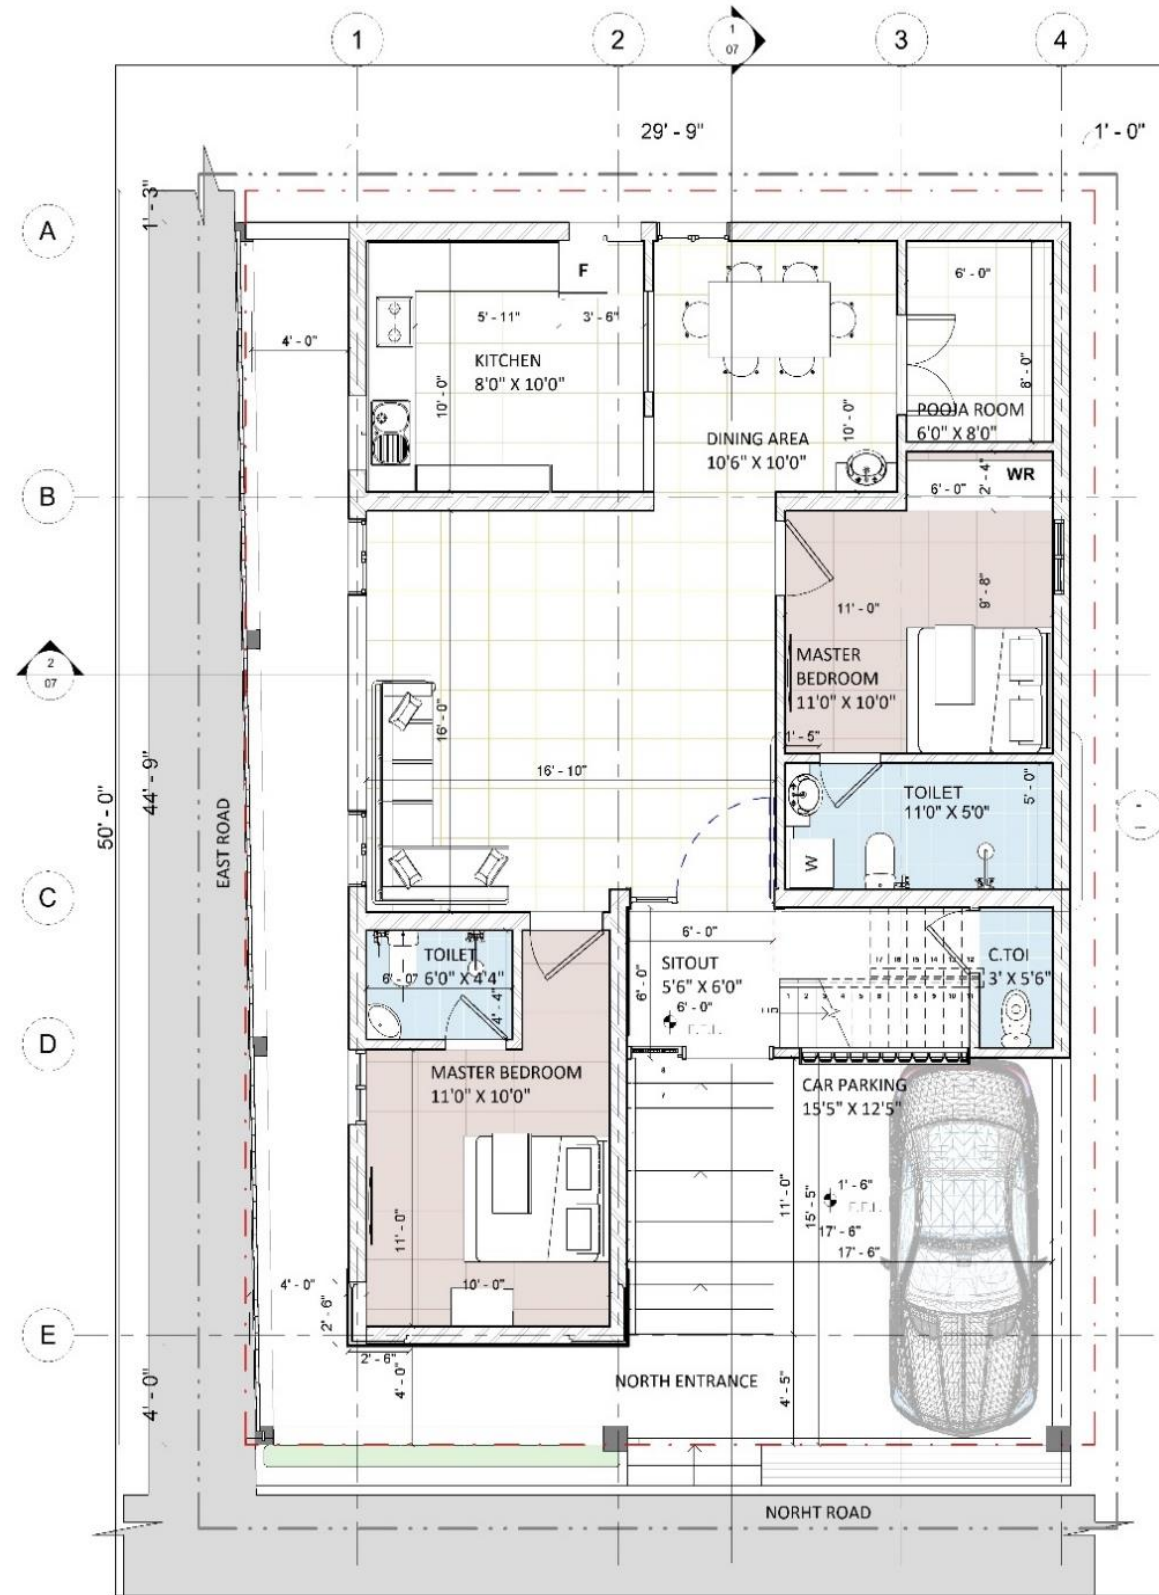

Sheet Title : GROUND FLOOR PLAN
Client Name : VS CHANDRAN VILLA @ Theni




Project Number : 028
Date : 05 / 11 / 2022
Scale : 1 : 50
Sheet No : 02
Detailed by : PC
Approved by : Ar.Pravin Chandran
Revision no :
Revision Date :

PC designs
Copyright



Architects & Builders
Bangalore | Chennai | Theni
Mob: 7845223384
www.pcdesigns.in

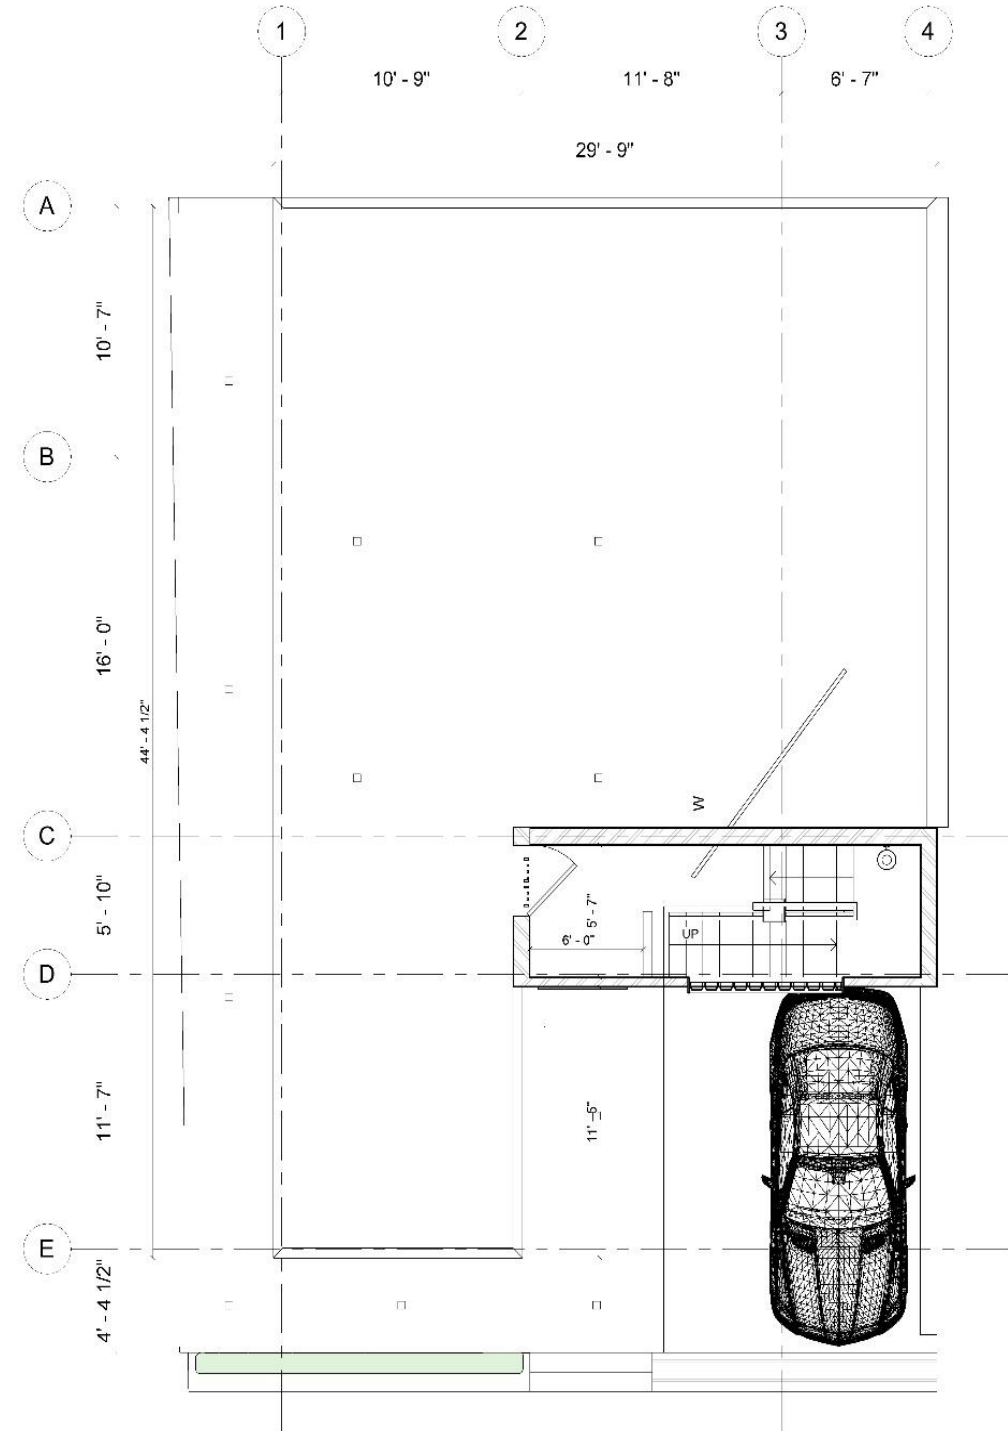

Sheet Title : FIRST FLOOR PLAN
Client Name : VS CHANDRAN VILLA @ Theni



Project Number : 028
Date : 05 / 11 / 2022
Scale : 1 : 50
Sheet No : 03
Detailed by : Ar.Abrarizhan
Approved by : Ar.Delvi
Revision no :
Revision Date :


PC designs
Copyright



Architects & Builders
Bangalore | Chennai | Theni
Mob: 7845223384
www.pcdesigns.in



PC designs
Architecture & Construction

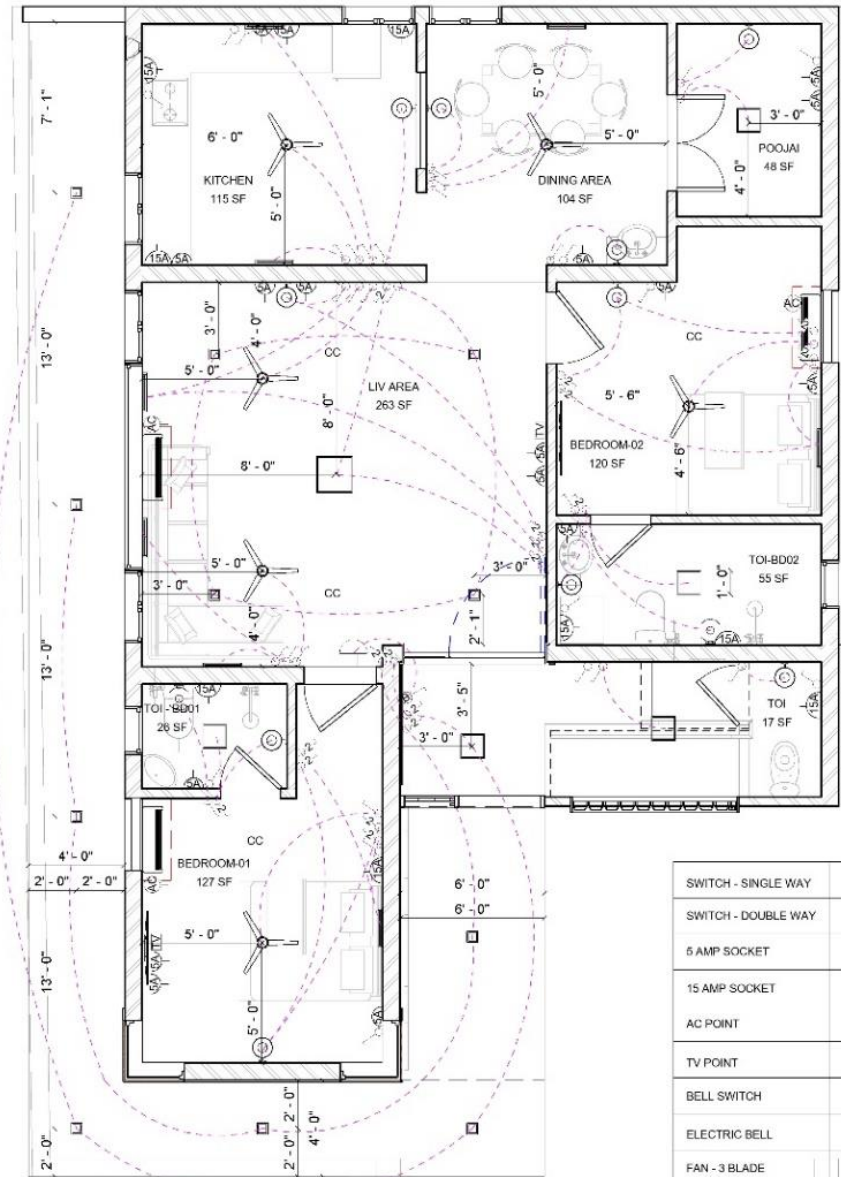

SWITCH - SINGLE WAY	1
SWITCH - DOUBLE WAY	2
5 AMP SOCKET	5A
15 AMP SOCKET	15A
AC POINT	AC
TV POINT	TV
BELL SWITCH	BS
ELECTRIC BELL	EB
FAN - 3 BLADE	F3B
SQUARE LIGHT	SL
TUBELIGHT	TL

LIGHTING FIXTURE SCHEDULE

LIGHT TYPE	LIGHT COLOR	Count	AMP
CEILING SURFACE MOUNT	LW	5	
DECOR LIGHT	VW	1	
LED HOLDER	RB	7	
LED LIGHT	LW	1	
MIRROR LIGHT	VW	1	
SMALL SPOT LIGHT	VW	1	
SPOT LIGHT	VW	7	
SPOT LIGHT_INTERIOR	VW	4	
TUDE LIGHT	LW	8	

Sheet Title : GF - ELECTRICAL LAYOUT

Client Name : VS CHANDRAN VILLA @ Theni



Project Number : 028

Date : 05 / 11 / 2022

Scale : 1 : 50

Sheet No : 04

Detailed by : PC

Approved by : PC

Revision no :


Revision Date :

PC designs


Copyright



Architects & Builders
Bangalore | Chennai | Theni
Mob: 7845223384
www.pcdesigns.in

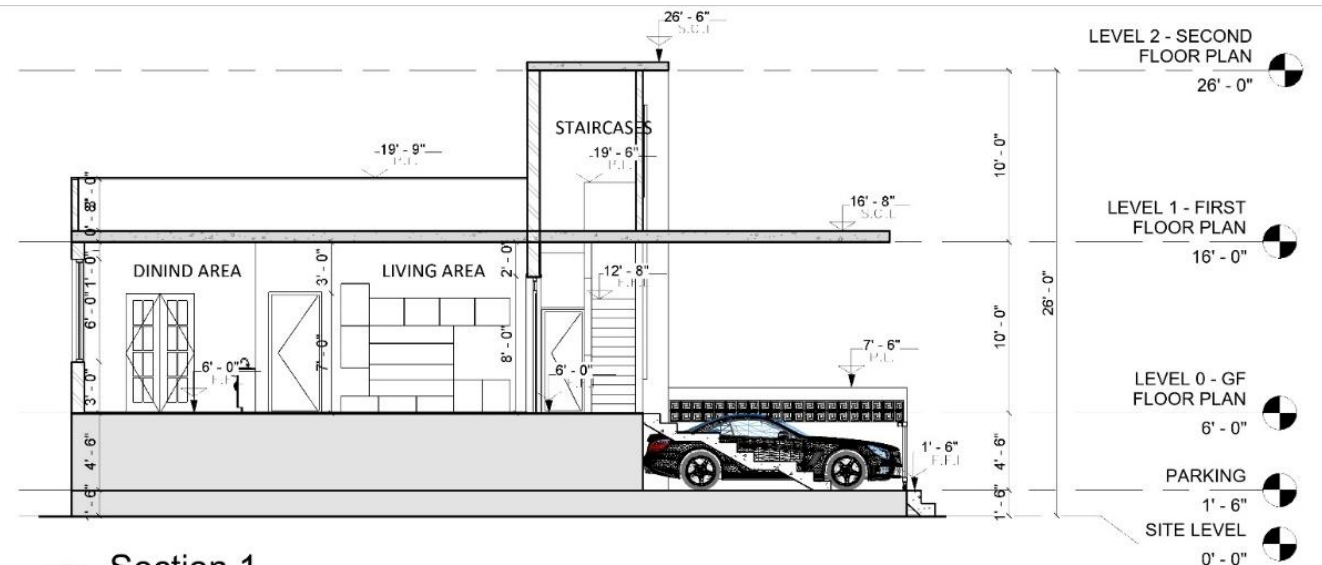


1 Section 1
1 : 75


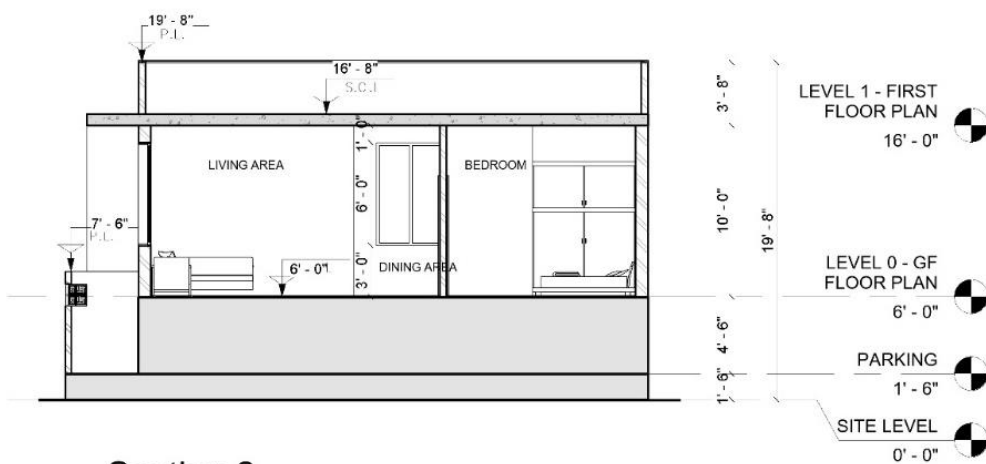


2 Section 2
1 : 75



PC designs
Architecture & Construction

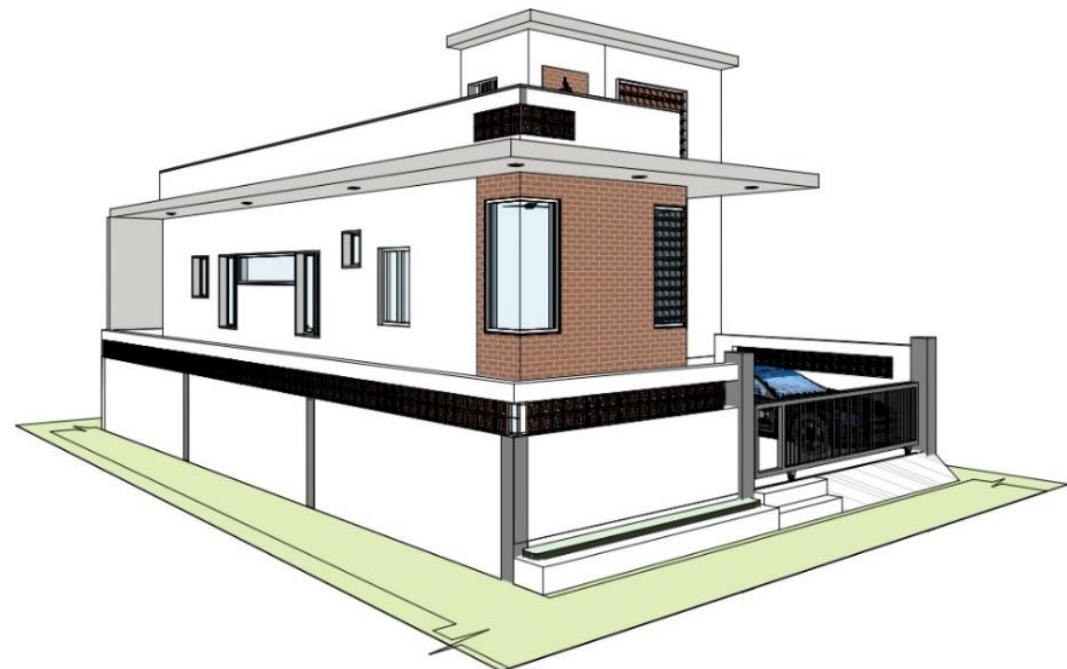

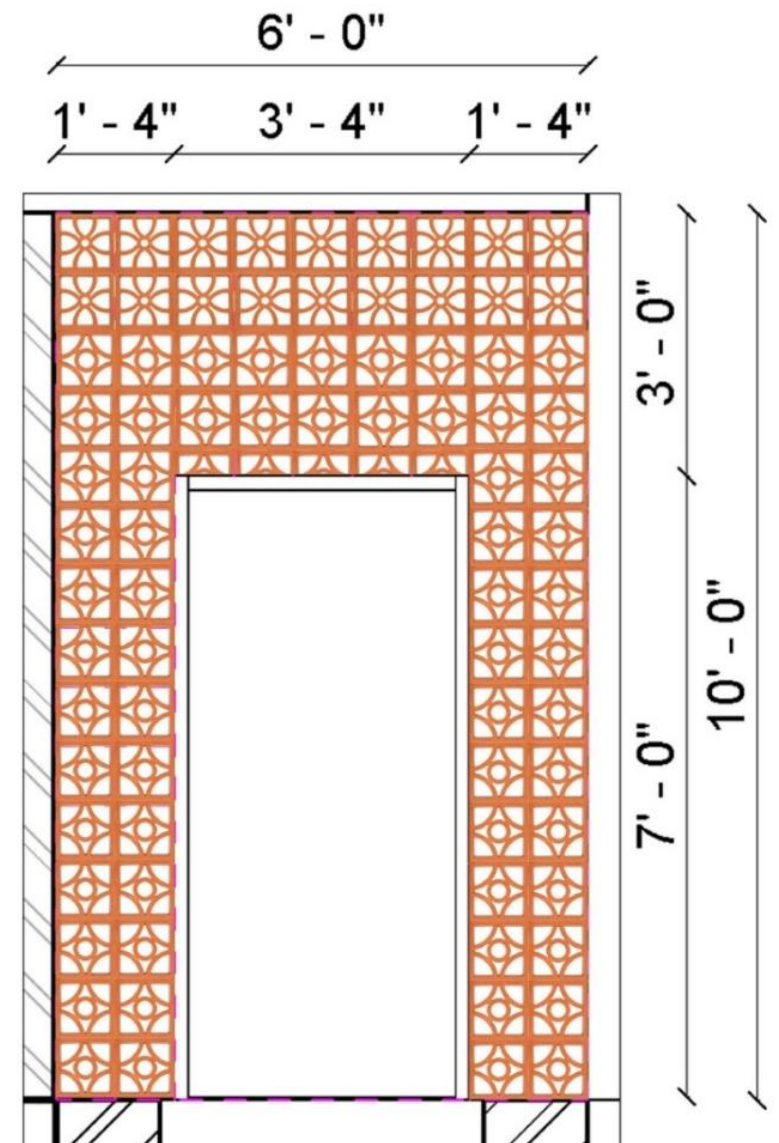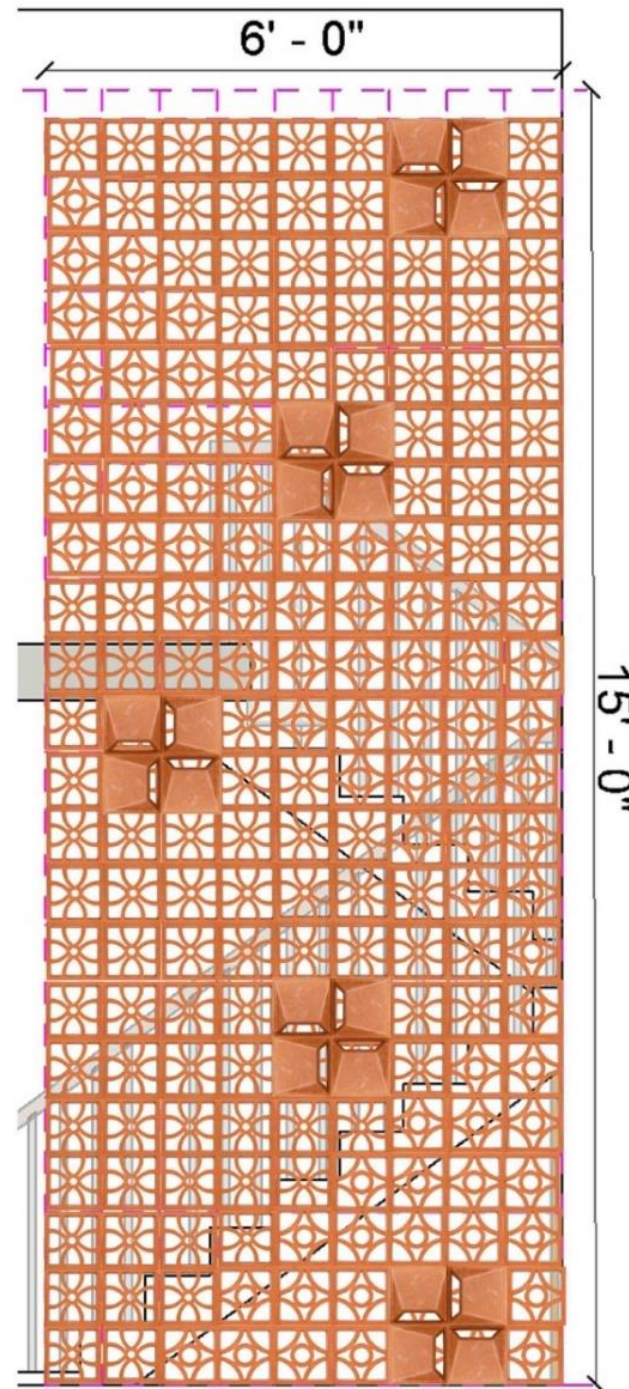

1 JAALI DESIGN DETAILS




PC designs
Architecture & Construction



FACADE ELEVATION

- ❖ JAALI DESIGN
- ❖ CORNER WINDOW
- ❖ BRICK CLADDING
- ❖ CANTILEVER PROJECTION
- ❖ CNC CUTTING

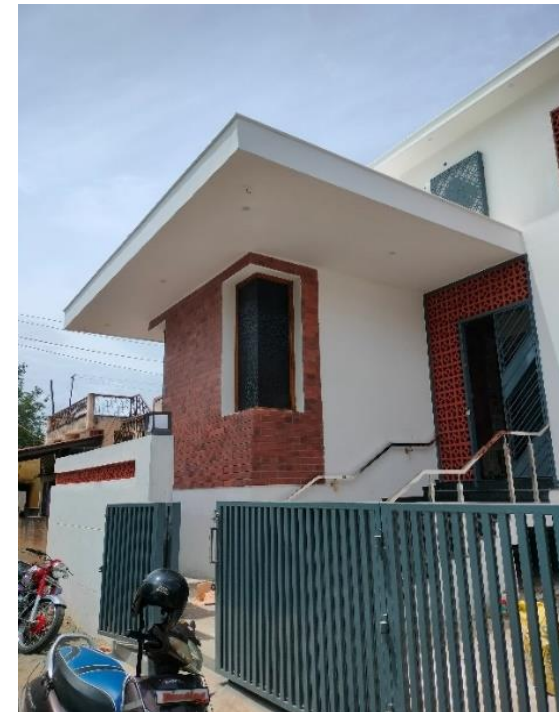





PC designs
Architecture & Construction



FACADE
ELEVATION





NIGHT VIEW

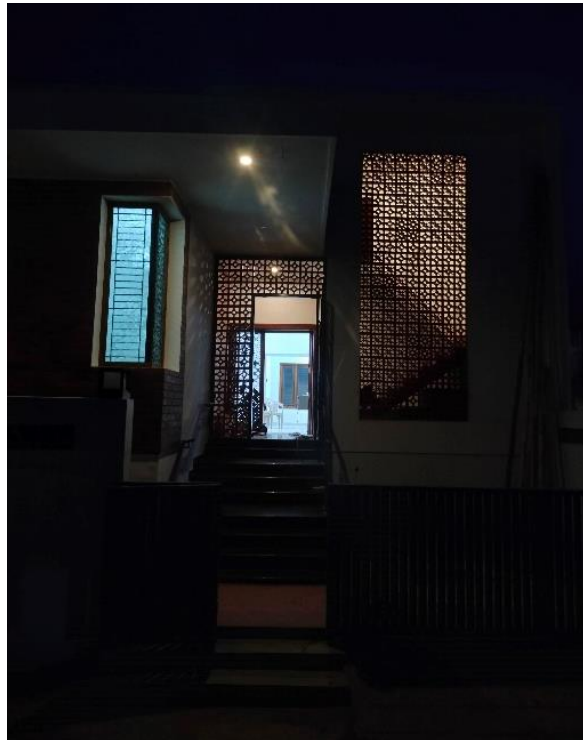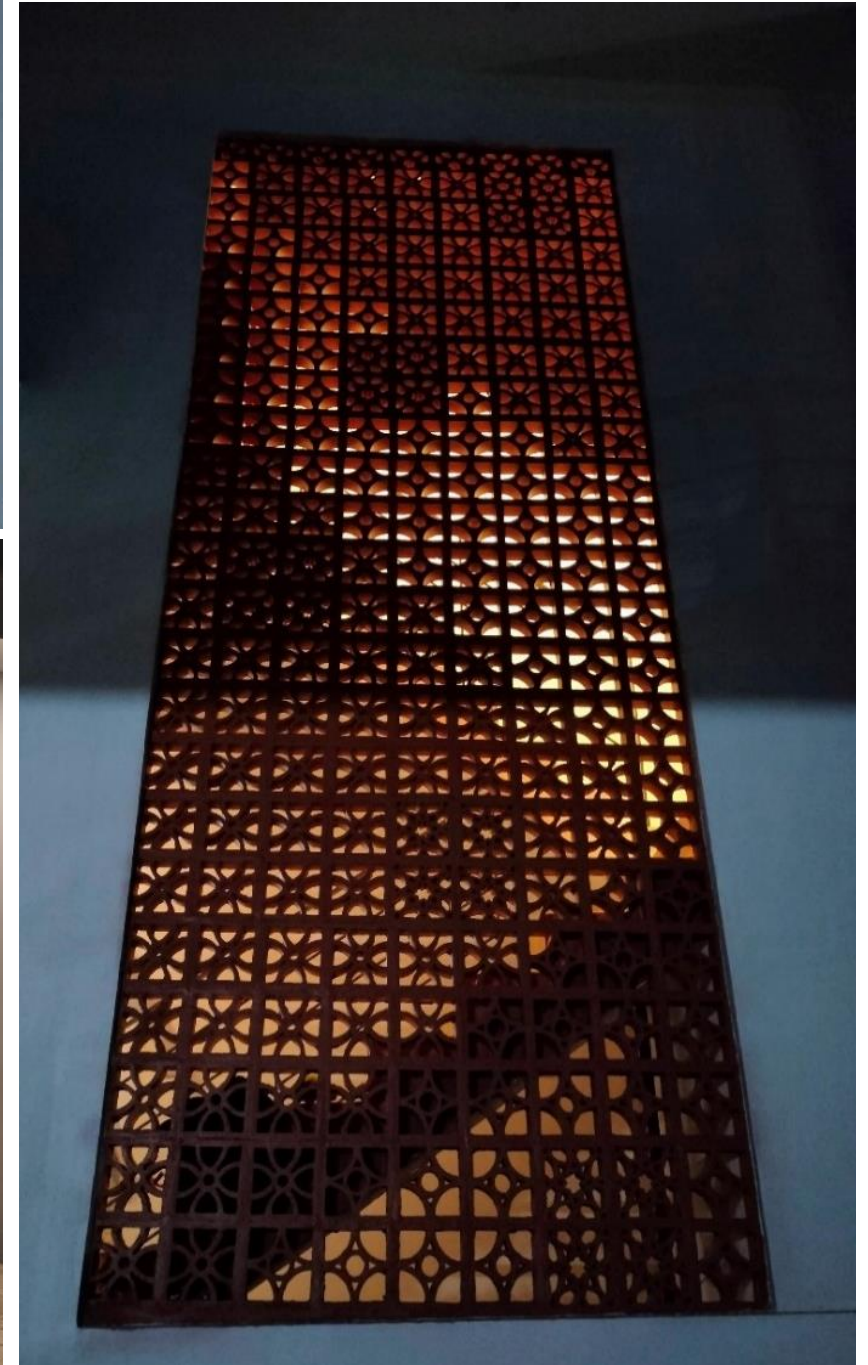





PC designs
Architecture & Construction

TV UNIT

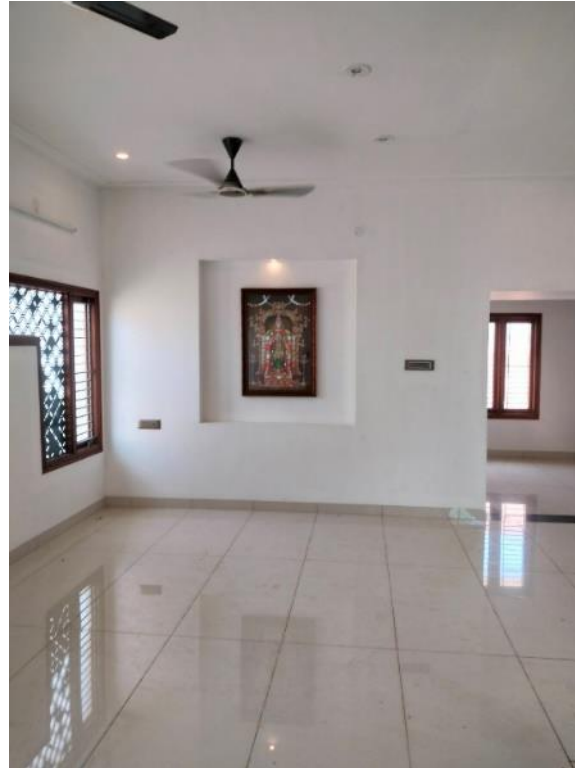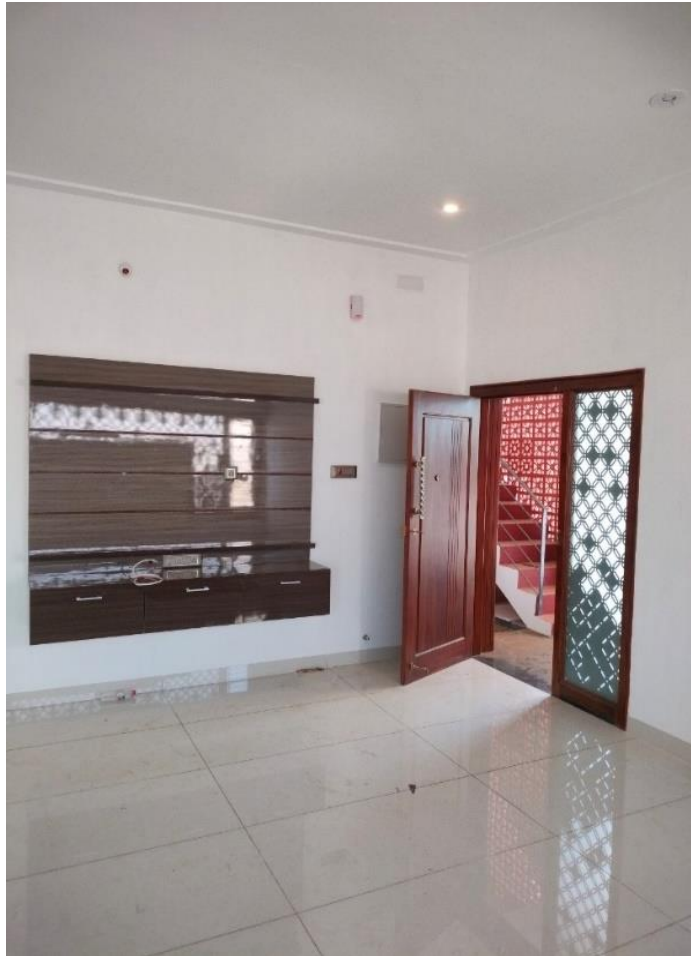

INTERIORS

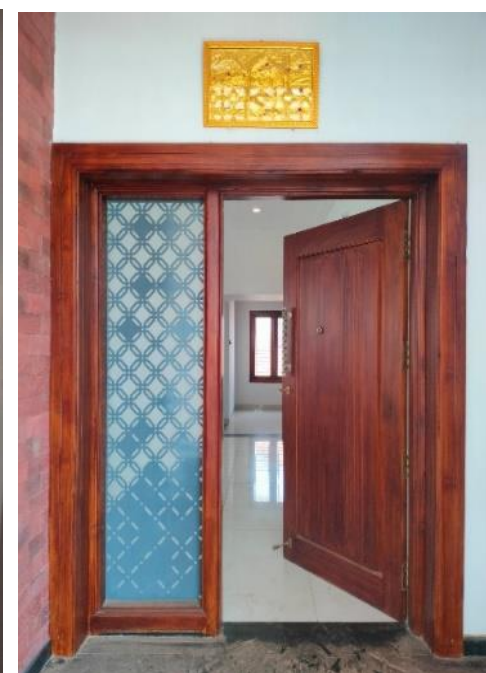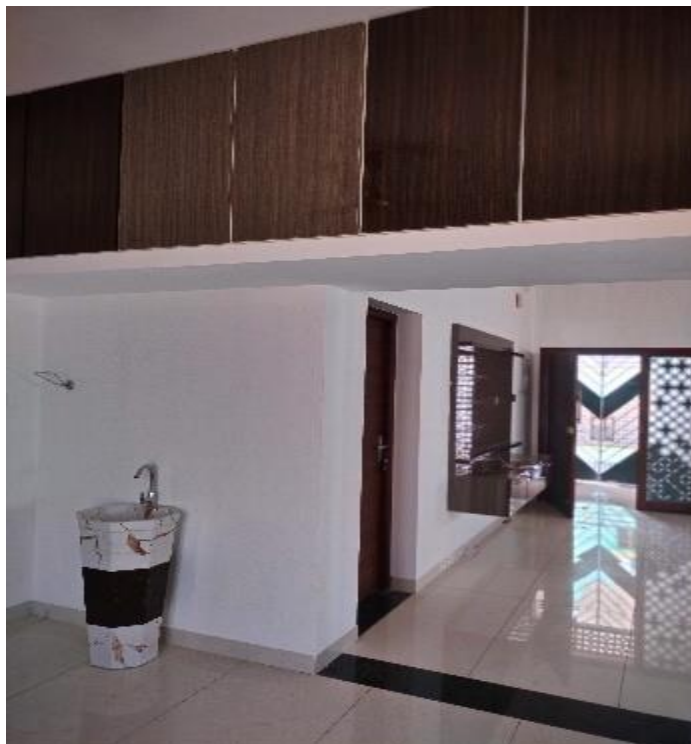

MAIN DOORS



PC designs
Architecture & Construction

02 RAJARAM VILLA

CLIENT - RAJARAM
TYPOLOGY - RESIDENCE
LOCATION - TIRUCHENGODE
SCOPE - DESIGN
AREA - 4000 Sqft



ARCHITECTURE | CONSTRUCTION | INTERIOR | MANAGEMENT | BIM | DIGITAL

www.pcdesigns.in | 7845223384



PC designs
chitecture & Construction




Sheet Title
GROUND FLOOR PLAN
Client Name
RAJARAM VILLA

ORIENTATION

Project Number : RD18 Sheet No : A002
Date : 17/10/2021 Drawn by : A/Pravin Chandran
Scale : 1 : 70

PC designs
Architects & Builders
Bangalore | Chennai | Thiruvananthapuram
Mob: 7845223384
www.pcdesigns.in

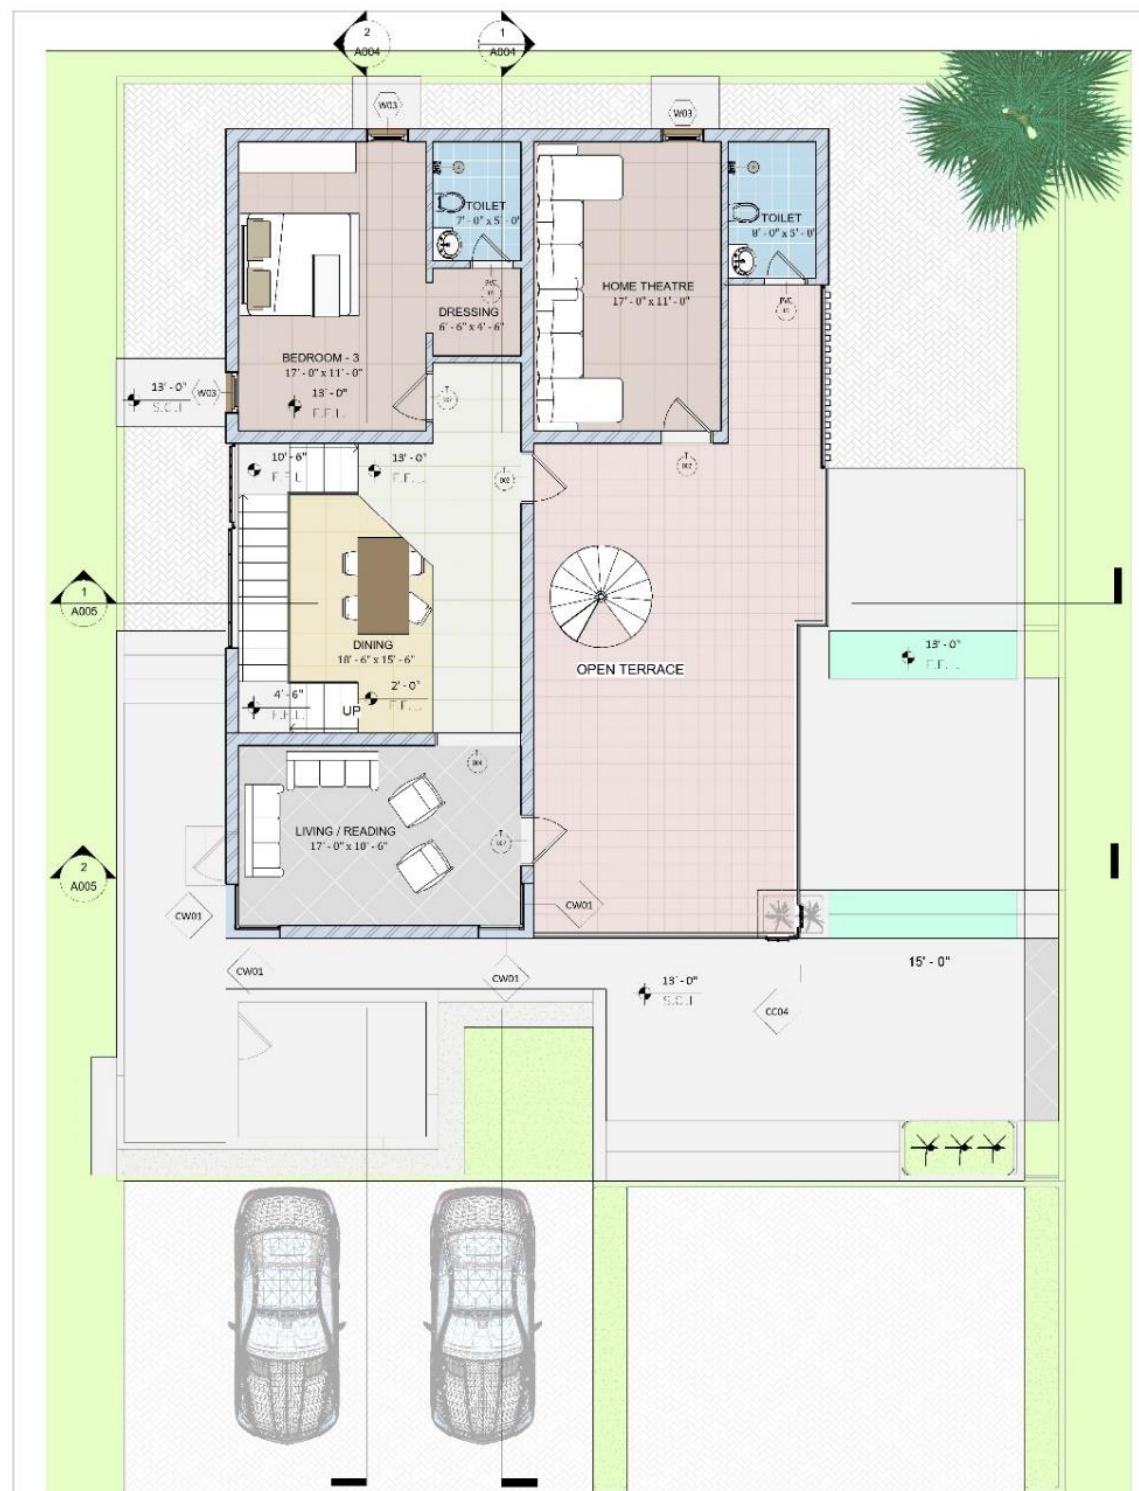

Sheet Title
FIRST FLOOR PLAN
Client Name
RAJARAM VILLA

ORIENTATION

Project Number : RD18 Sheet No : A003
Date : 17/10/2021 Drawn by : A/Pravin Chandran
Scale : 1 : 70

PC designs
Architects & Builders
Bangalore | Chennai | Thiruvananthapuram
Mob: 7845223384
www.pcdesigns.in



Sheet Title

SECTION - 01

ORIENTATION



Project Number : R010

Date : 17/10/2021

Scale : 1 : 60

Sheet No

A004

Detailed by

Ar Pravin Chandru

Project Name

Proposed Residence for Mr.V.Rajaram Villa @
Tiruchengode

PC designs

Copyright



Architects & Builders
Bangalore | Chennai | Thiruv
Mob: 7845223384
www.pcdesigns.in



PC designs
Architecture & Construction



Sheet Title :
SECTION - 02



Project Number : R018
Date : 17/10/2021
Scale : 1 : 70

Sheet No : A005
Designed by : Ar Pravin Chandru

Project Name :
Proposed Residence for Mr.V.Rajaram Villa @
Tiruchengode

PC designs
Copyright



Architects & Builders
Bangalore | Chennai | Thiruv
Mobi: 7845223384
www.pcdesign.in



PC designs
architecture & construction



Sheet Title :
ELEVATION - 01




Project Number : **R018** Sheet No : **A006**
Date : **17/10/2021** Drawn by : **Ar Pravin Chandre**
Scale : **1 : 75**

Project Name :
**Proposed Residence for Mr.V.Rajaram Villa @
Tiruchengode**

PC designs
Copyright




Architects & Builders
Bangalore | Chennai | Thiruv
Mob: 7845223384
www.pcdesigns.in

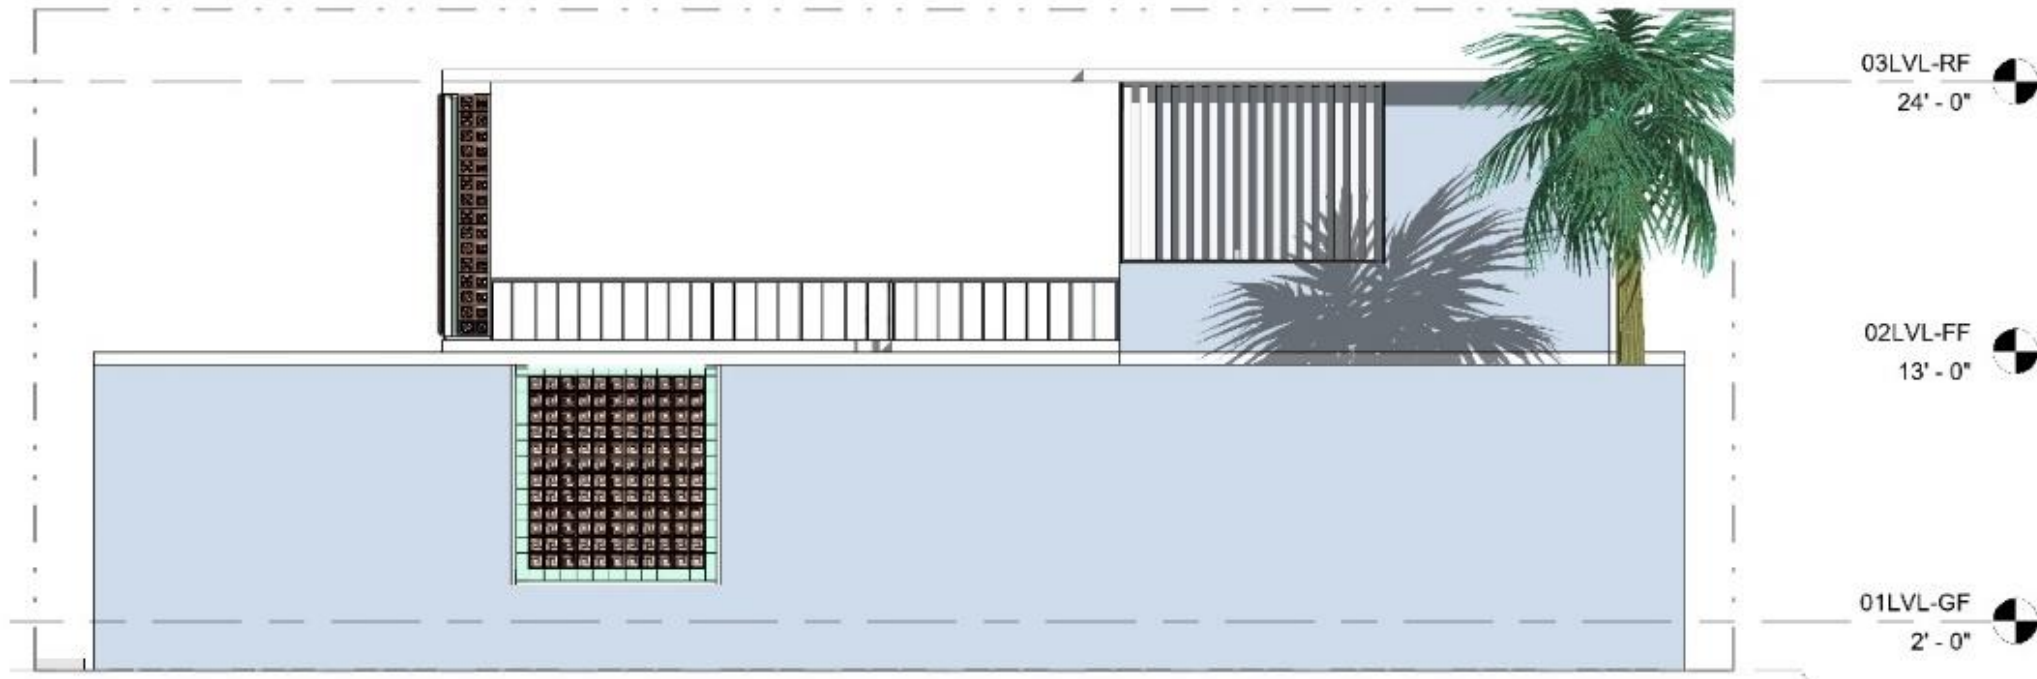

NORTH ELEVATION

1

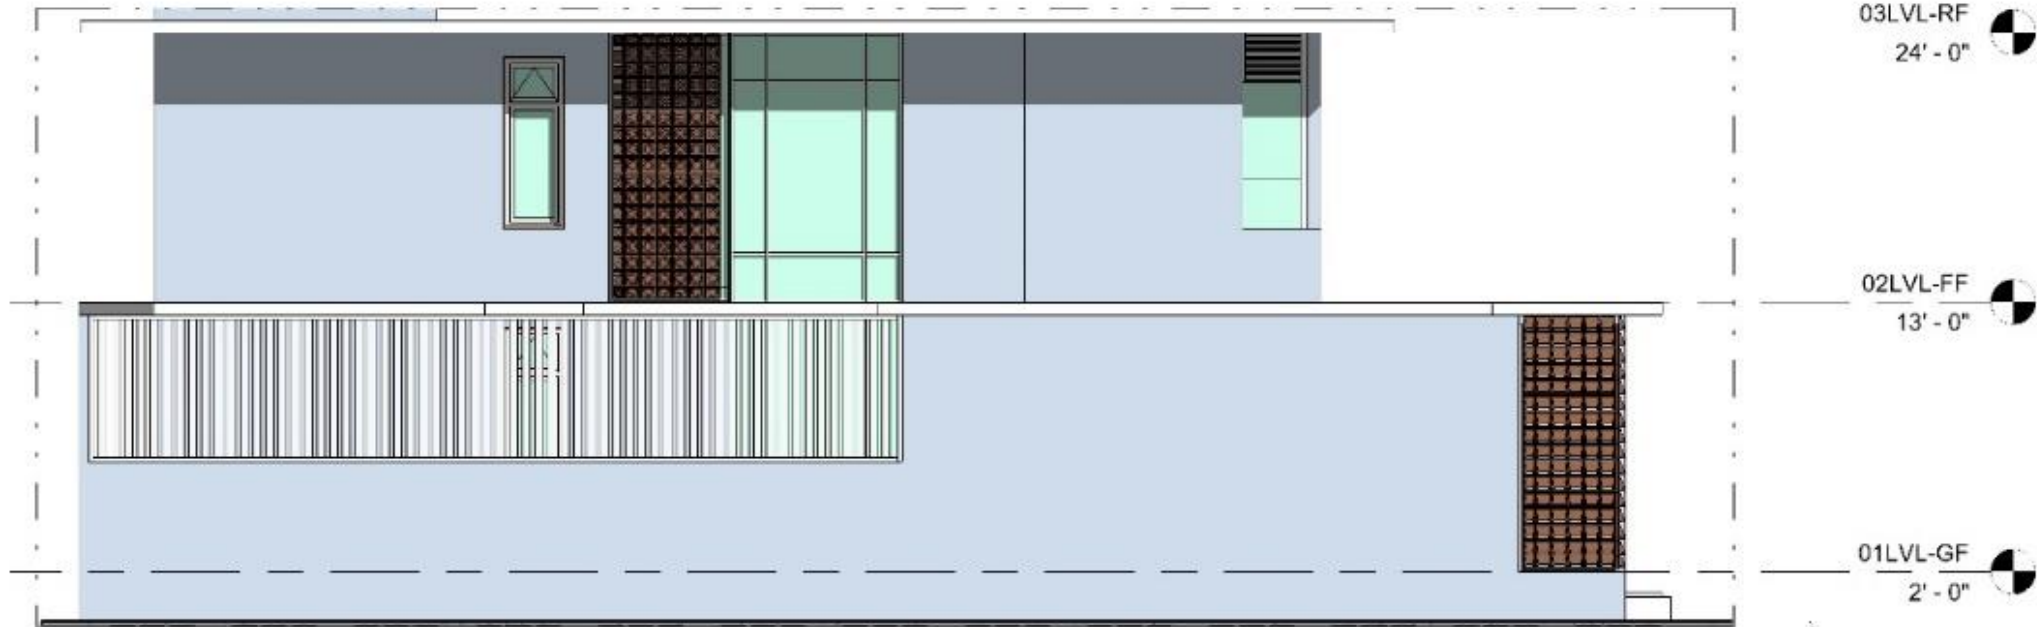

SOUTH ELEVATION

2

Sheet Title :
ELEVATION - 02

ORIENTATION :



Project Number : R010 Sheet No : A007
Date : 17/10/2021 Detailed by : Author
Scale : 1 : 10

Project Name :

Proposed Residence for Mr.V.Rajaram Villa @
Tiruchengode


PC designs
Copyright




Architects & Builders
Bangalore | Chennai | Thiruvananthapuram
Mob: 7845223384
www.pcdesigns.in




PC designs
Architecture & Construction

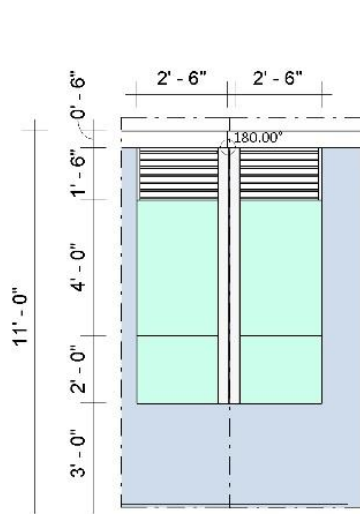


1 CW 01
1 : 50

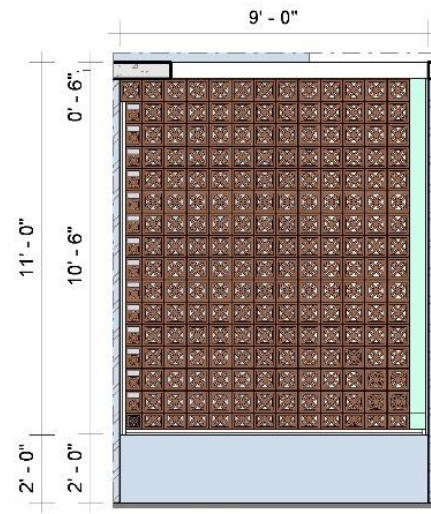


2 CC 01
1 : 50

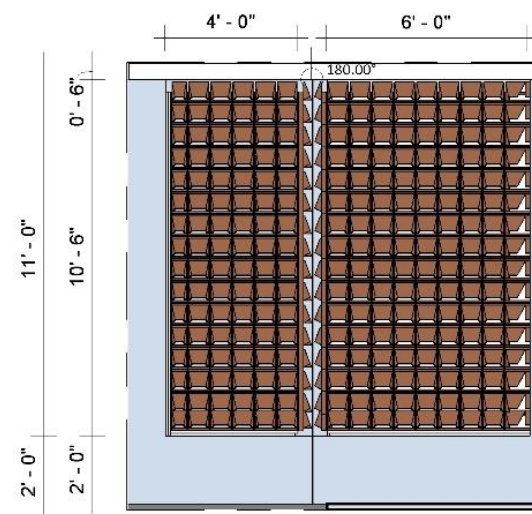


3 CC 02
1 : 50

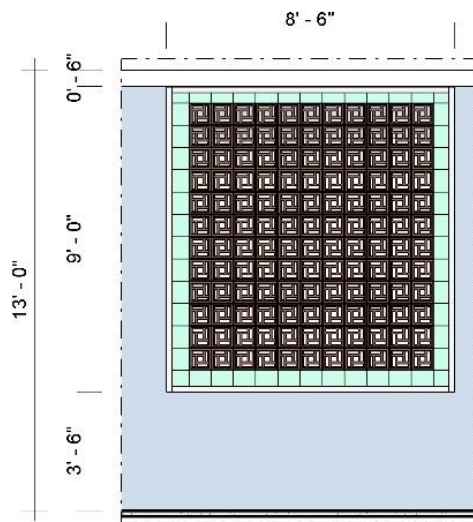


4 CC 03
1 : 50

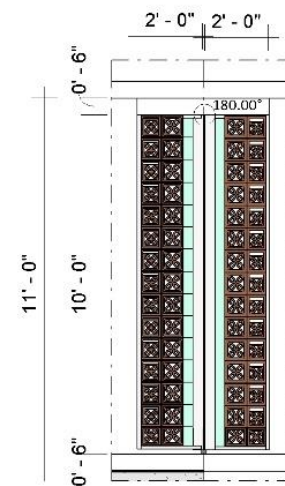

5 CC 04
1 : 50

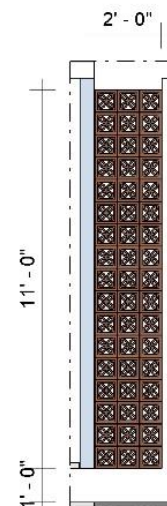

6 CC 05
1 : 50

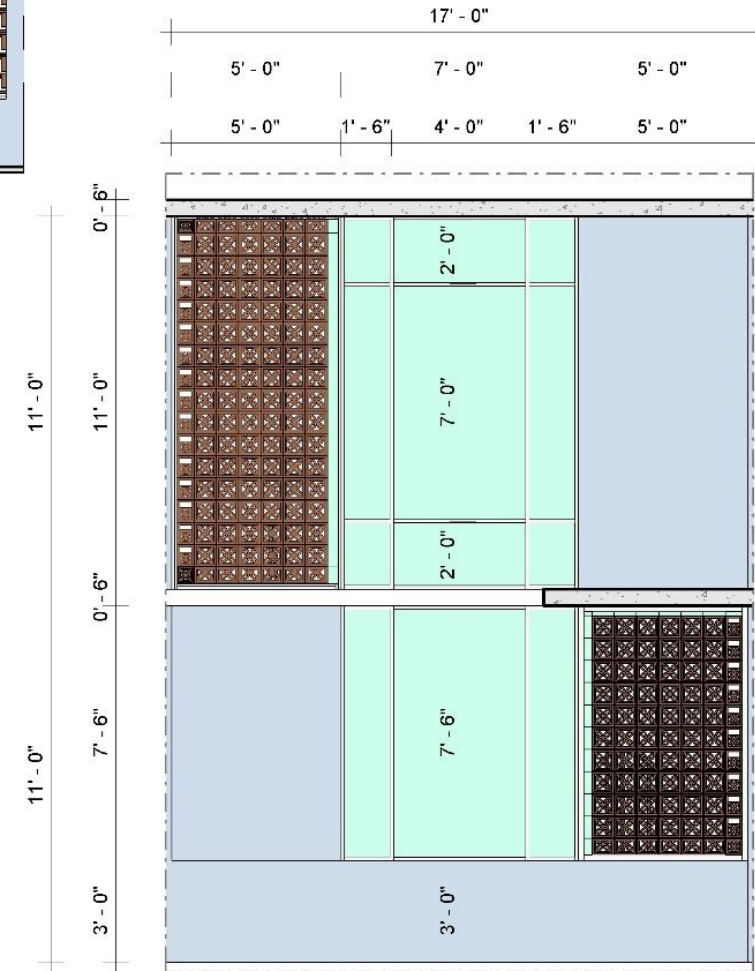

7 DG 01
1 : 50

Sheet Title :
SCHEDULE OF OPENING 01




Project Number : R018 Sheet No : A011
Date : 17/10/2021 Detailed by : Ar Pravin Chandru
Scale : 1 : 50

Project Name :
Proposed Residence for Mr.V.Rajaram Villa @
Tiruchengode

PC designs
Copyright



Architects & Builders
Bangalore | Chennai | Thani
Mob: 7845223384
www.pcdesign.in

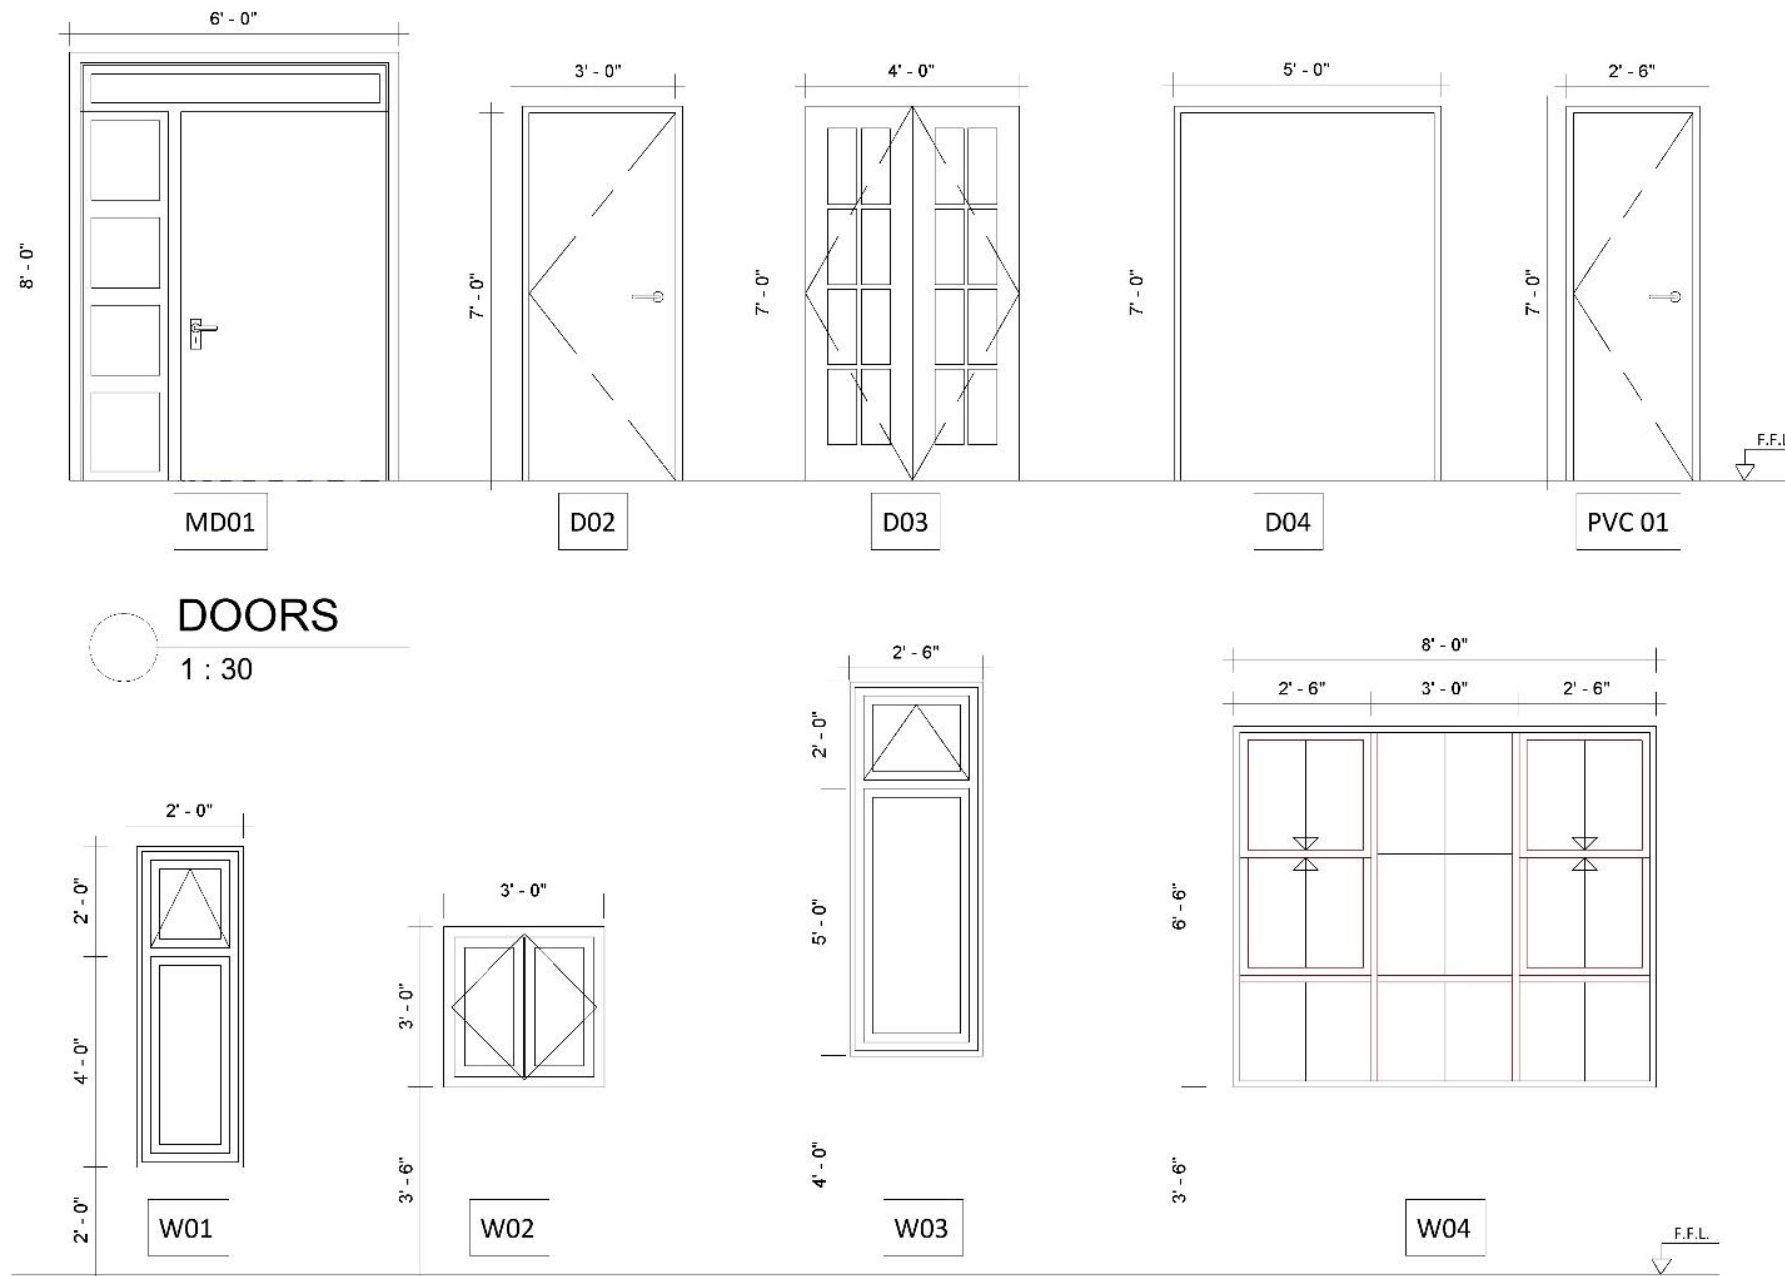

FACADE CLADDING SCHEDULE					
TYPE	TYPE COMMENT	TYPE MARK	HEIGHT	LENGHT	AREA SQFT
CC01					
FLORAL CLAY_01	CC	CC01	10' - 6"	9' - 6"	99.39 ft ²
					99.39 ft ²
CC02					
CAMP CLAY	CC	CC02	10' - 0"	6' - 0"	60.85 ft ²
CAMP CLAY	CC	CC02	10' - 0"	4' - 0"	39.72 ft ²
					100.57 ft ²
CC03					
FLORAL CLAY_02	CC	CC03	9' - 0"	8' - 6"	76.50 ft ²
					76.50 ft ²
CC04					
FLORAL CLAY_03	CC	CC04	10' - 0"	2' - 0"	19.45 ft ²
FLORAL CLAY_03	CC	CC04	10' - 0"	2' - 0"	19.53 ft ²
					38.98 ft ²
CC05					
FLORAL CLAY_04	CC	CC05	2' - 0"	2' - 0"	3.88 ft ²
FLORAL CLAY_04	CC	CC05	7' - 6"	5' - 6"	40.31 ft ²
FLORAL CLAY_04	CC	CC05	11' - 0"	5' - 6"	59.13 ft ²
FLORAL CLAY_04	CC	CC05	11' - 0"	2' - 6"	26.99 ft ²
					130.30 ft ²
CW01					
Exterior Glazing	CW	CW01	7' - 6"	7' - 0"	52.50 ft ²
Exterior Glazing	CW	CW01	11' - 0"	7' - 0"	77.00 ft ²
Exterior Glazing	CW	CW01	8' - 0"	2' - 6"	20.19 ft ²
Exterior Glazing	CW	CW01	8' - 0"	2' - 6"	20.33 ft ²
Exterior Glazing	CW	CW01	8' - 0"	2' - 6"	19.85 ft ²
Exterior Glazing	CW	CW01	8' - 0"	2' - 6"	20.00 ft ²
Exterior Glazing	CW	CW01	7' - 6"	2' - 6"	19.08 ft ²
Exterior Glazing	CW	CW01	7' - 6"	2' - 6"	19.25 ft ²
					248.20 ft ²
MG01					
FABRICATION	MG	MG01	6' - 0"	33' - 0"	198.87 ft ²
FABRICATION	MG	MG01	7' - 6"	11' - 0"	81.45 ft ²
					280.32 ft ²
20					974.25 ft ²



PC designs
Architecture & Construction

CONCEPTUAL DEVELOPMENT

FACADE DESIGN



ARCHITECTURE | CONSTRUCTION | INTERIOR | MANAGEMENT | BIM | DIGITAL

www.pcdesigns.in | 7845223384



PC designs
Architecture & Construction

CONCEPTUAL DEVELOPMENT

FACADE DESIGN



ARCHITECTURE | CONSTRUCTION | INTERIOR | MANAGEMENT | BIM | DIGITAL

www.pcdesigns.in | 7845223384



PC designs
Architecture & Construction



3D VISUALISATION BUILDING RENDERING





PC designs
Architecture & Construction



3D VISUALISATION BUILDING RENDERING





PC designs
Architecture & Construction

03 SURESH VILLA


CLIENT - SURESH

TYPOLOGY - INTERIOR, RENOVATION


LOCATION - THENI

AREA - 1000 sqft




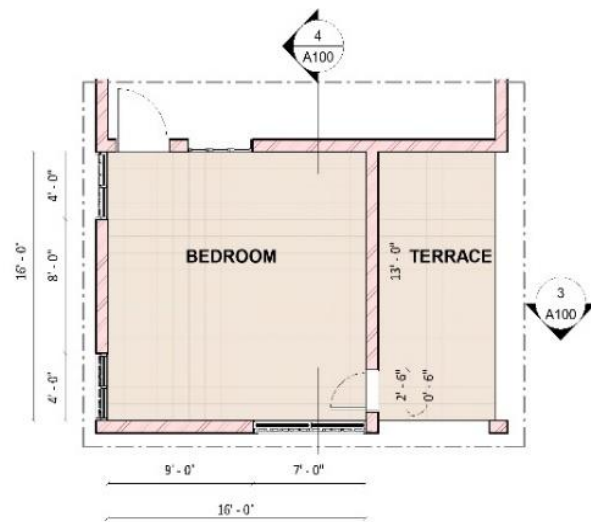

1 ROOM LAYOUT
1:75

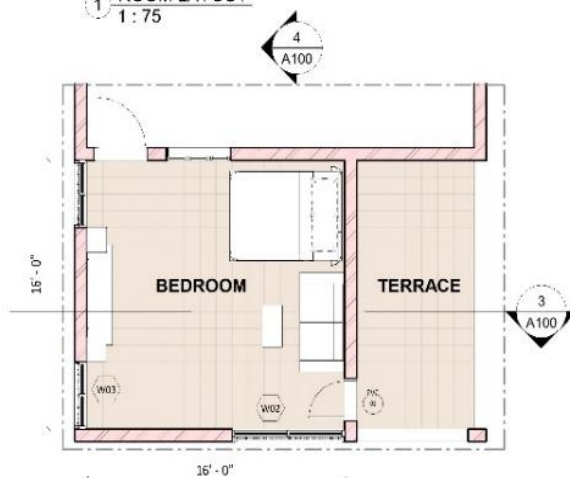


2 FURNITURE LAYOUT
1:75

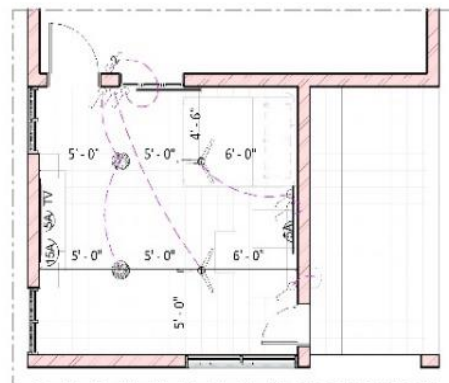


9 ELECTRICAL LAYOUT
1:75



SWITCH - SINGLE WAY	
SWITCH - DOUBLE WAY	
5 AMP SOCKET	
15 AMP SOCKET	
FAN - 3 BLADE	
TV POINT	
TUBELIGHT	
CEILING CLAMP	

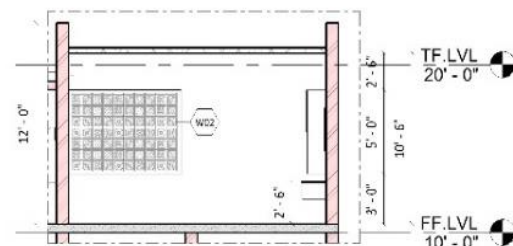

3 SECTION 01
1:75

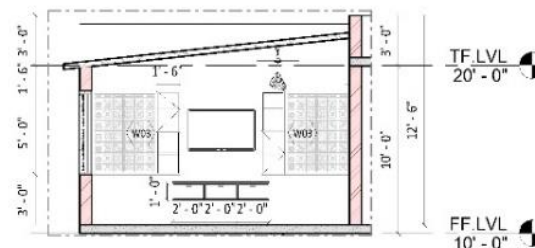

4 SECTION 02
1:75

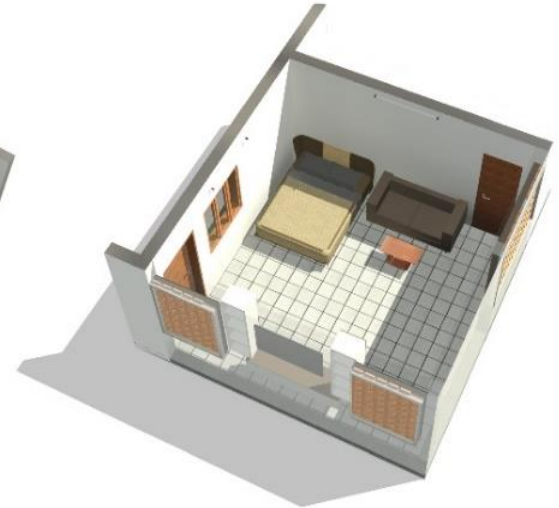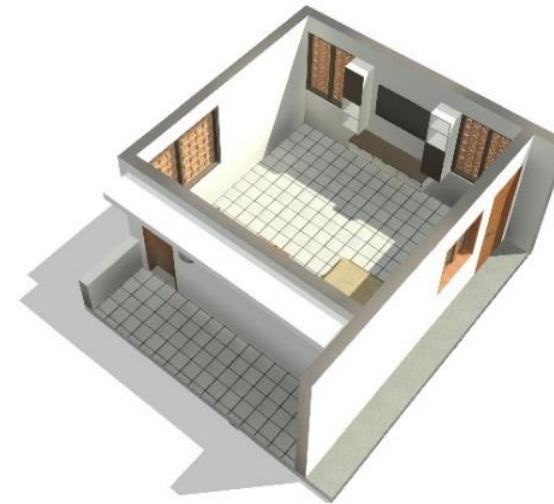

Sheet Title : DETAILED DESIGN LAYOUT

Client Name : RENOVATION OF HOME

ORIENTATION



Project Number : 036

Date : 30-11-2022

Scale : As indicated

Sheet No : A100

Detailed by : RK

Approved by : PC

Revision no : 1

Revision Date : 26/11/2022

PC designs

Copyright



Architects & Builders
Bangalore | Chennai | Madurai
Mob: 7845223384
www.pcdesigns.in

Sheet Title : 3D LAYOUTS

Client Name : RENOVATION OF HOME

ORIENTATION



Project Number : 036

Date : 30-11-2022

Scale :

Sheet No : A101

Detailed by : RK

Approved by : PC

Revision no : 1

Revision Date : 26/11/2022

PC designs


Copyright



Architects & Builders
Bangalore | Chennai | Madurai
Mob: 7845223384
www.pcdesigns.in



PC designs
Architecture & Construction

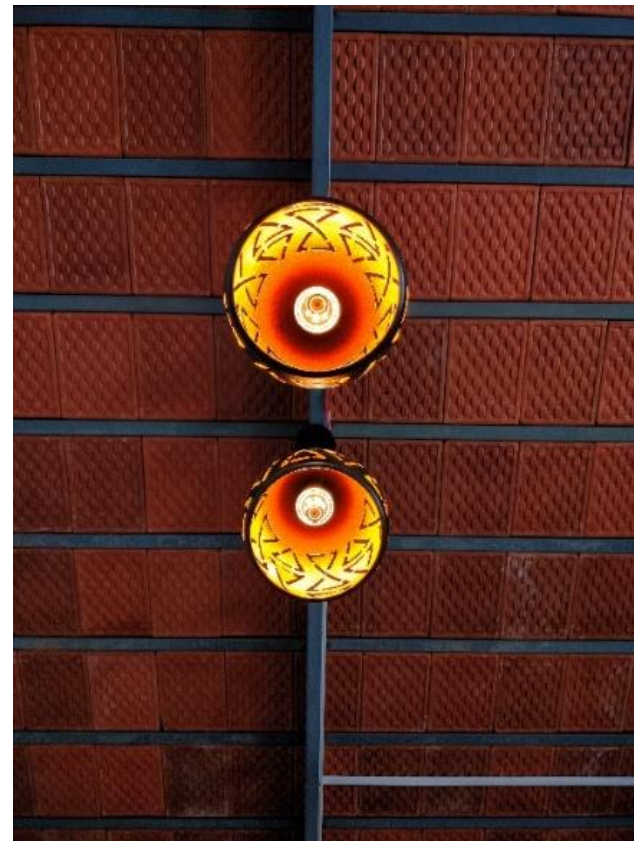



PC designs
Architecture & Construction



ARCHITECTURE | CONSTRUCTION | INTERIOR | MANAGEMENT | BIM | DIGITAL
www.pcdesigns.in | 7845223384



PC designs
Architecture & Construction

04 NAVEEN VILLA

CLIENT - NAVEEN

TYPOLOGY - CONSTRUCTION,
INTERIOR

LOCATION - THENI

AREA - 2000 sqft







ARCHITECTURE | CONSTRUCTION | INTERIOR | MANAGEMENT | BIM | DIGITAL

www.pcdesigns.in | 7845223384




PC designs
Architecture & Construction

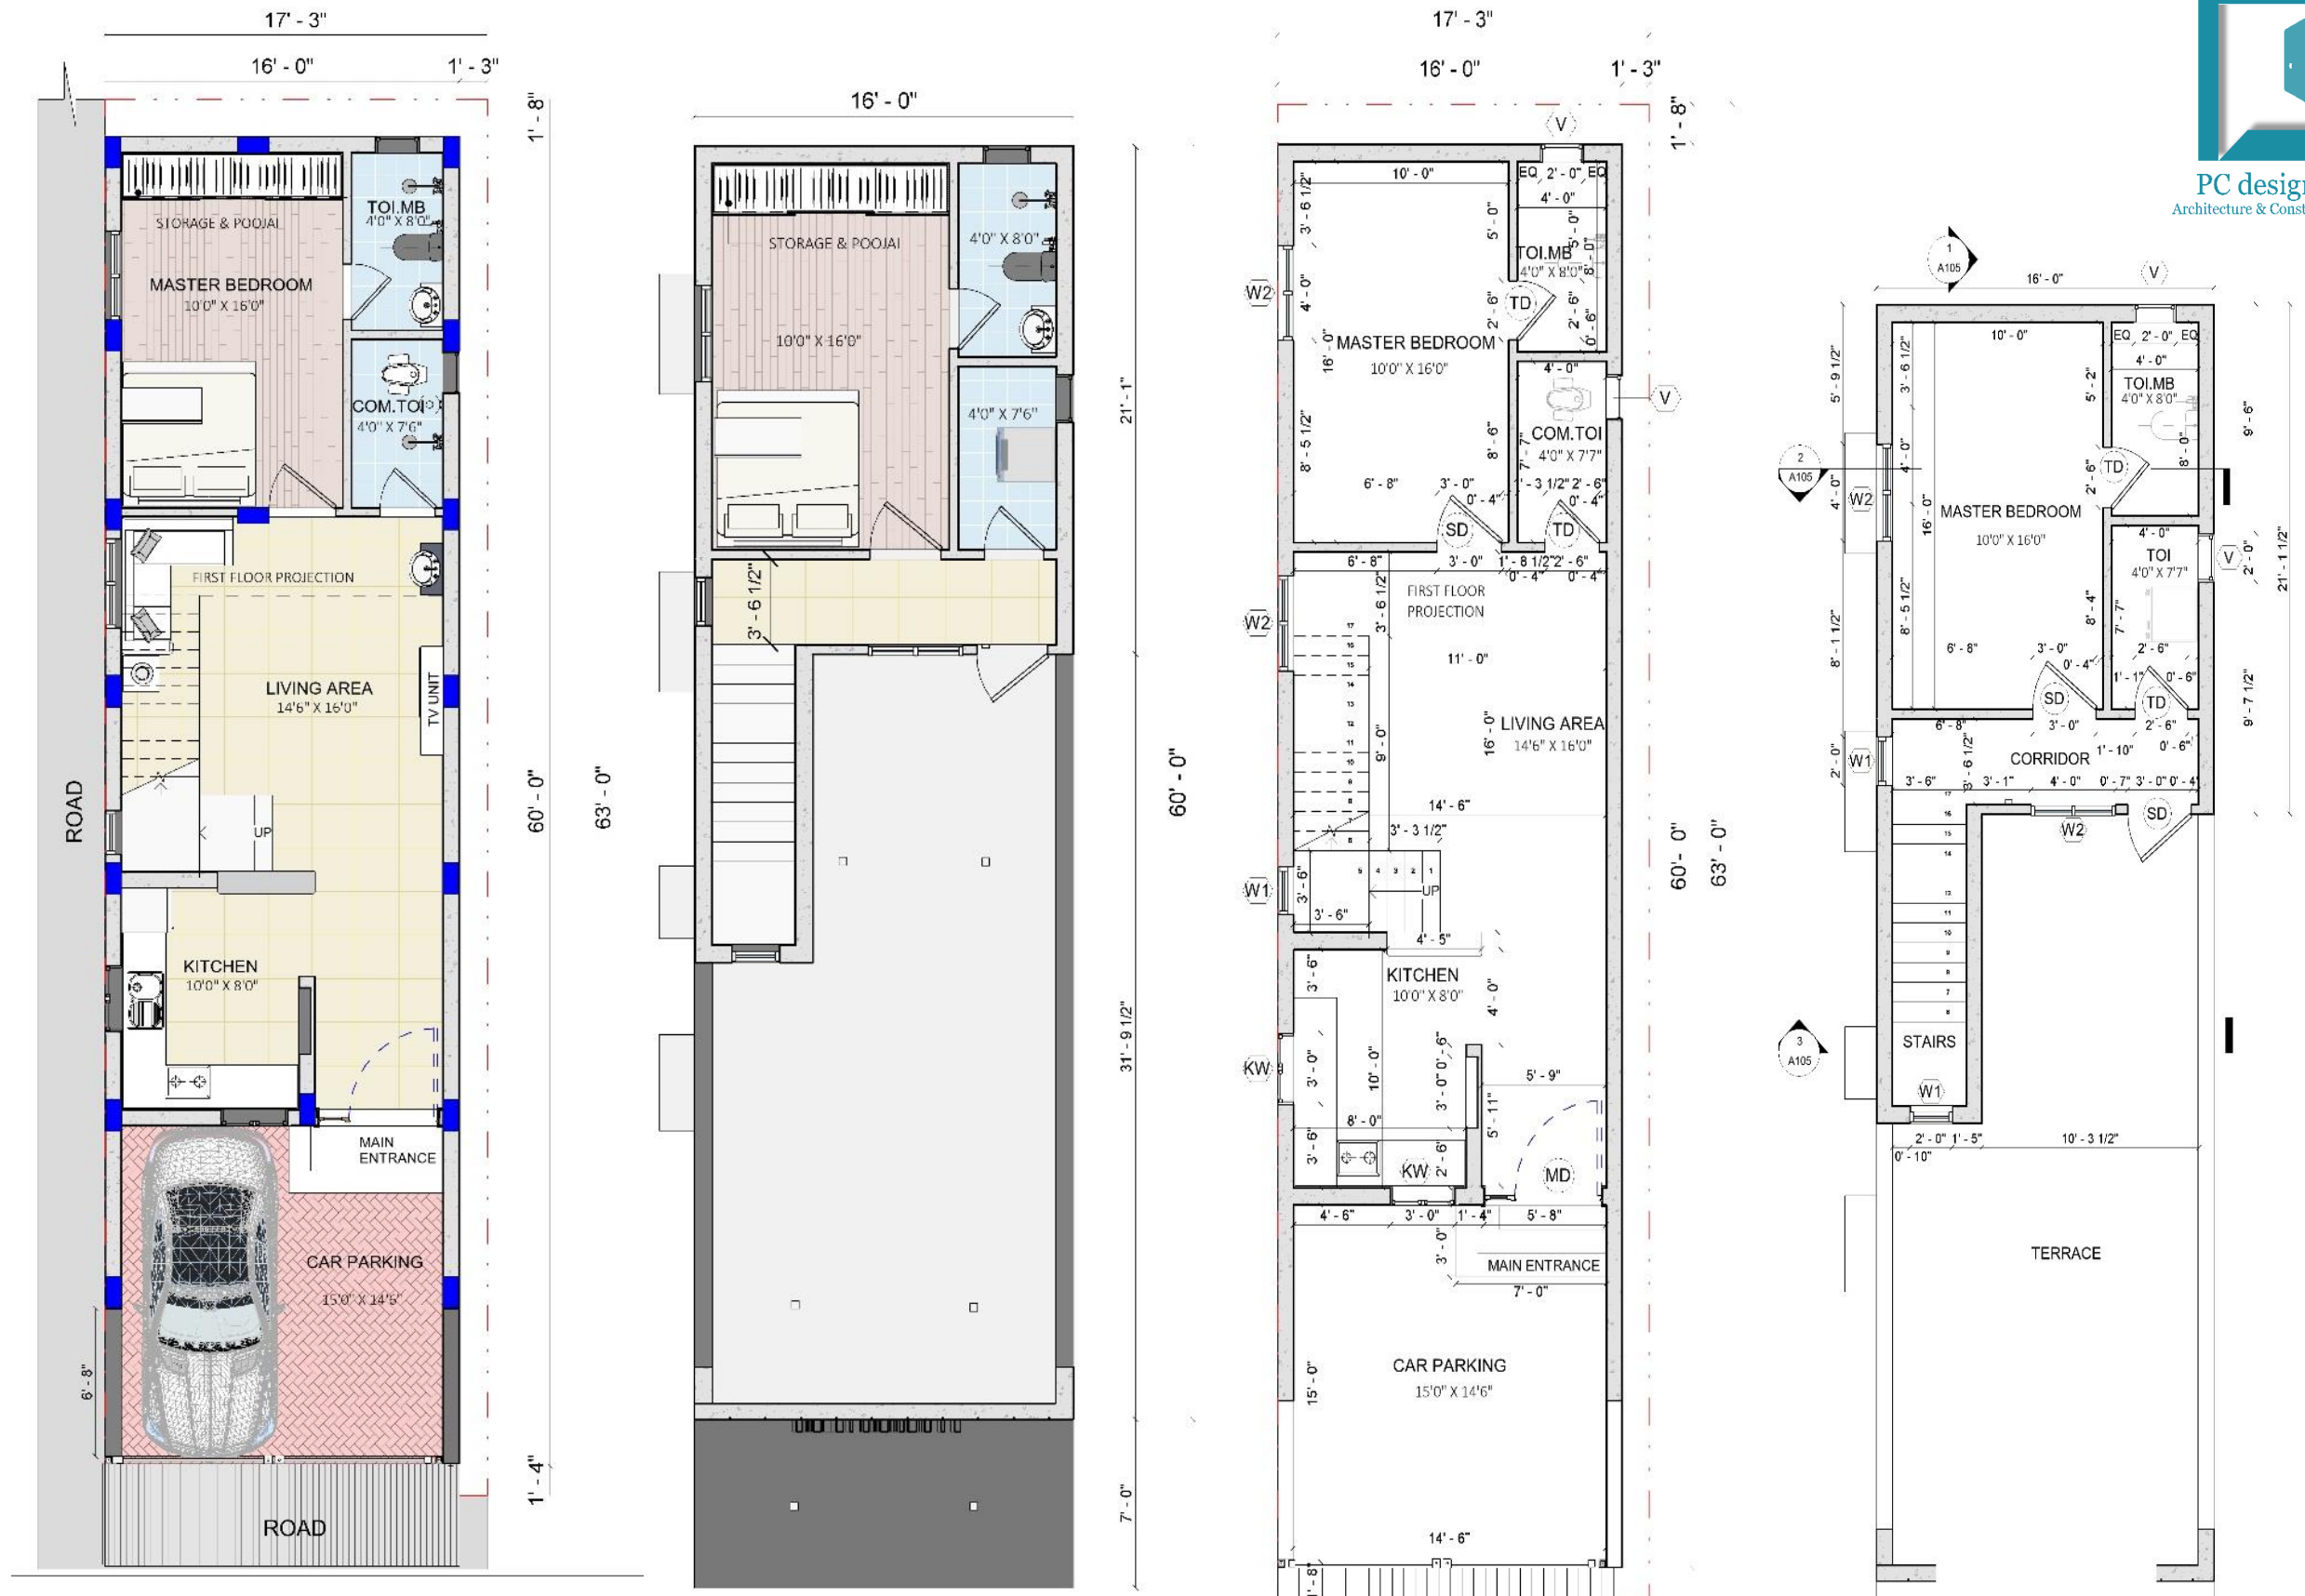


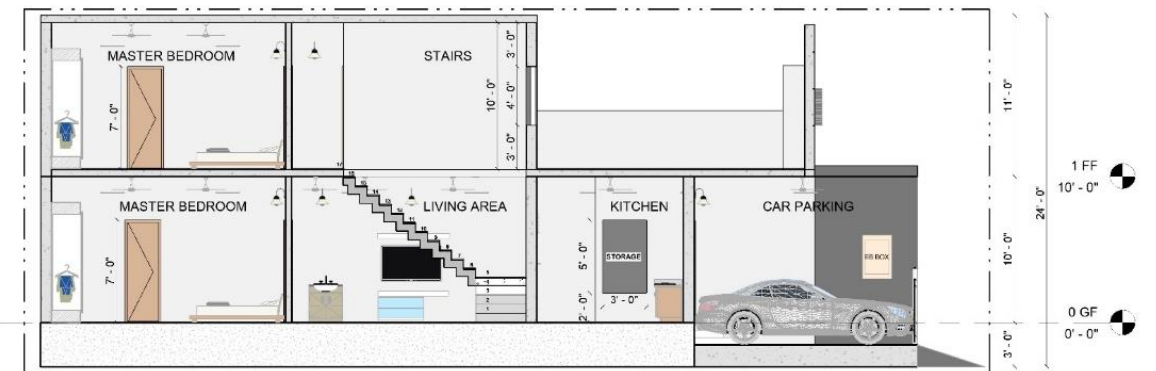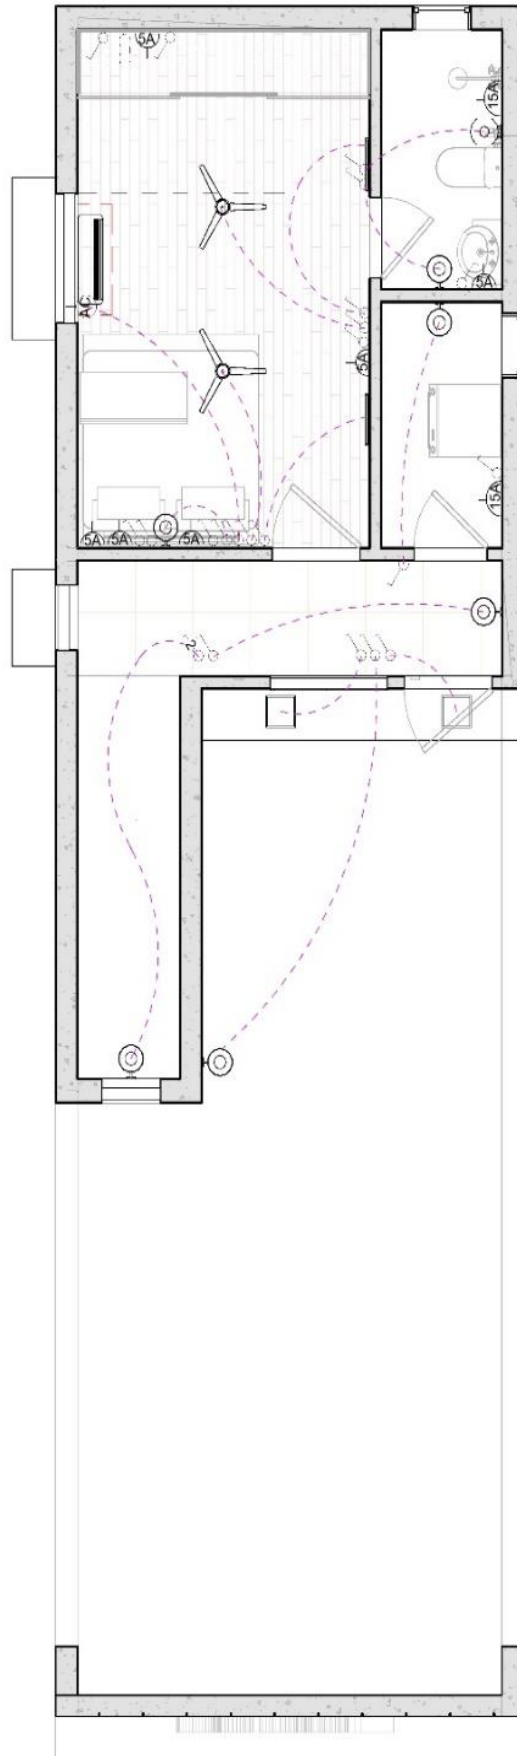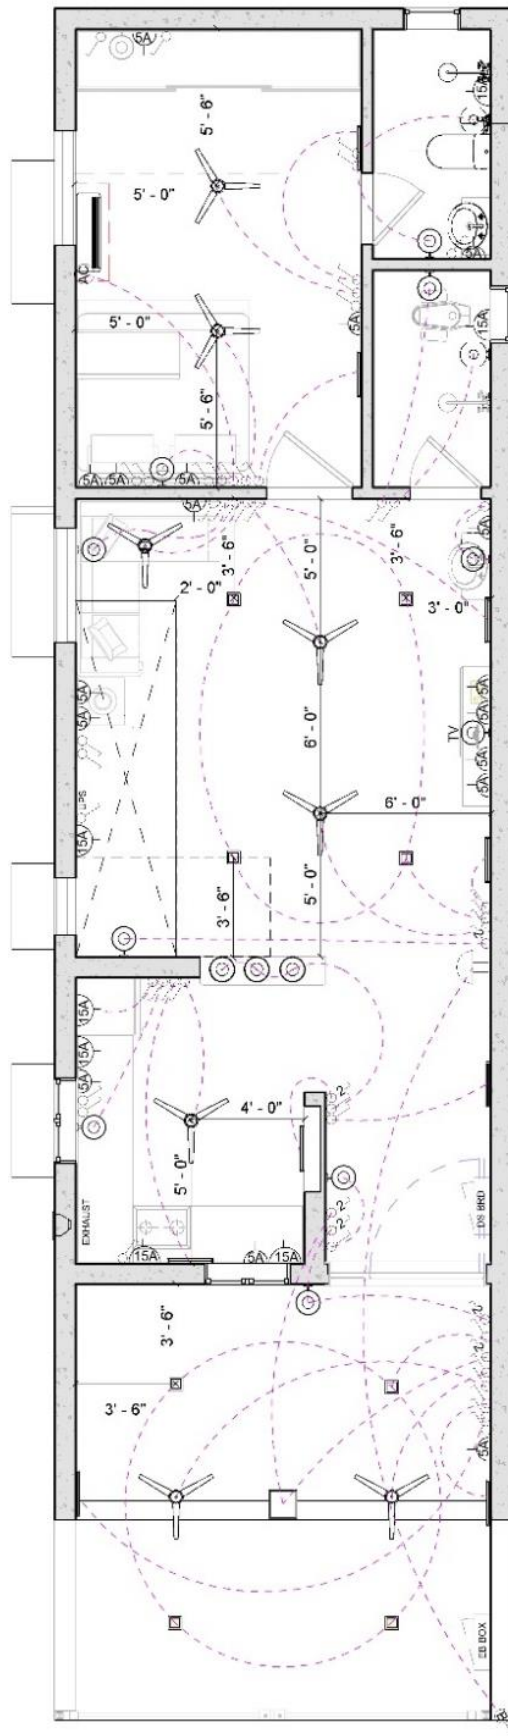

SECTION -01

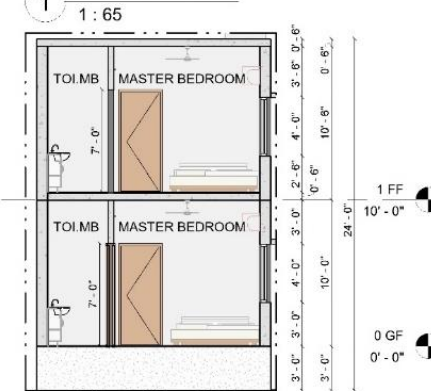


SECTION -02

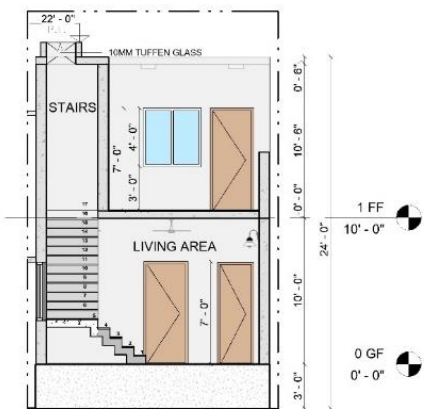


SECTION -03



PC designs
Architecture & Construction

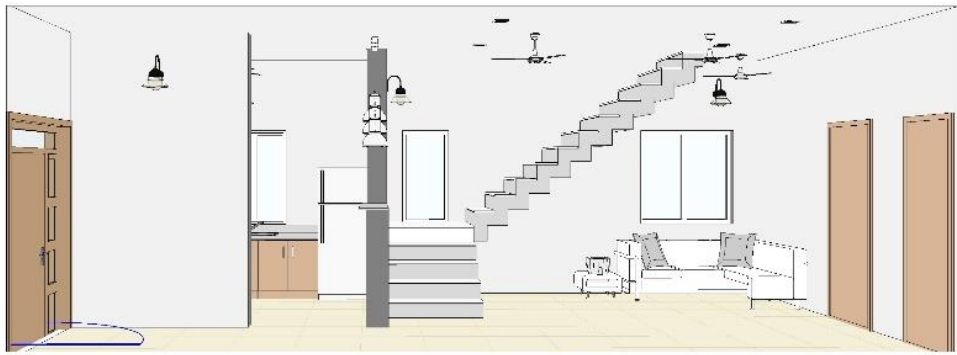

1 LIVING AREA-01

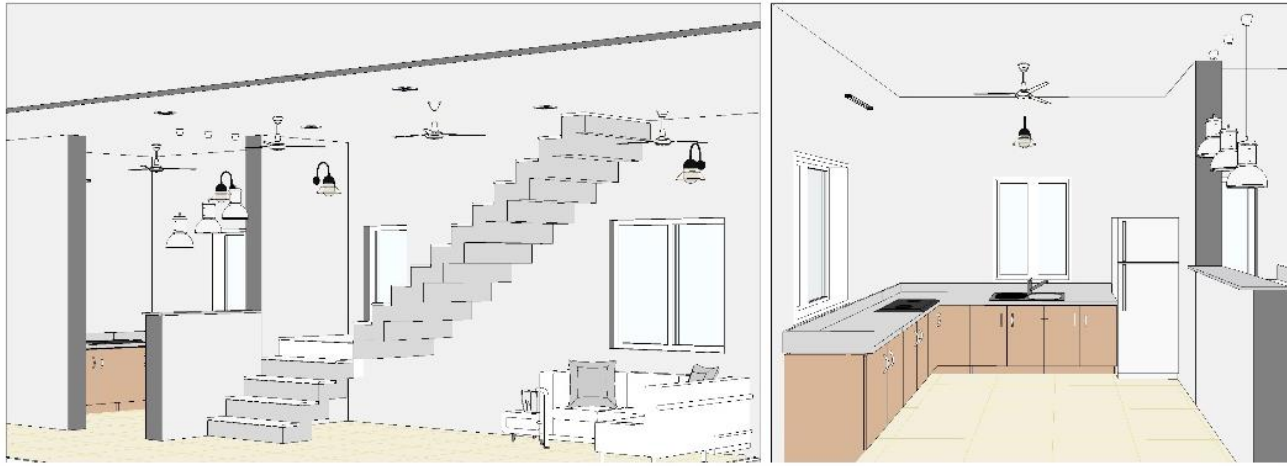

2 LIVING AREA-02

3 KITCHEN-01



4 LIVING AREA-03

5 KITCHEN-02





PC designs
Architecture & Construction

05 SRI BALAJI VILLA

CLIENT - Mr Chinnaraja
TYPOLOGY - RESIDENCE
LOCATION - THENI
SCOPE - CONSTRUCTION
AREA - 3000 Sqft



ARCHITECTURE | CONSTRUCTION | INTERIOR | MANAGEMENT | BIM | DIGITAL
www.pcdesigns.in | 7845223384

OPTIONAL - 01

CUBISM



OPTIONAL - 02

TERRACOTTA JALLI FACDE




ARCHITECTURE | CONSTRUCTION | INTERIOR | MANAGEMENT | BIM | DIGITAL

www.pcdesigns.in | 7845223384



PC designs
Architecture & Construction

10' - 0"

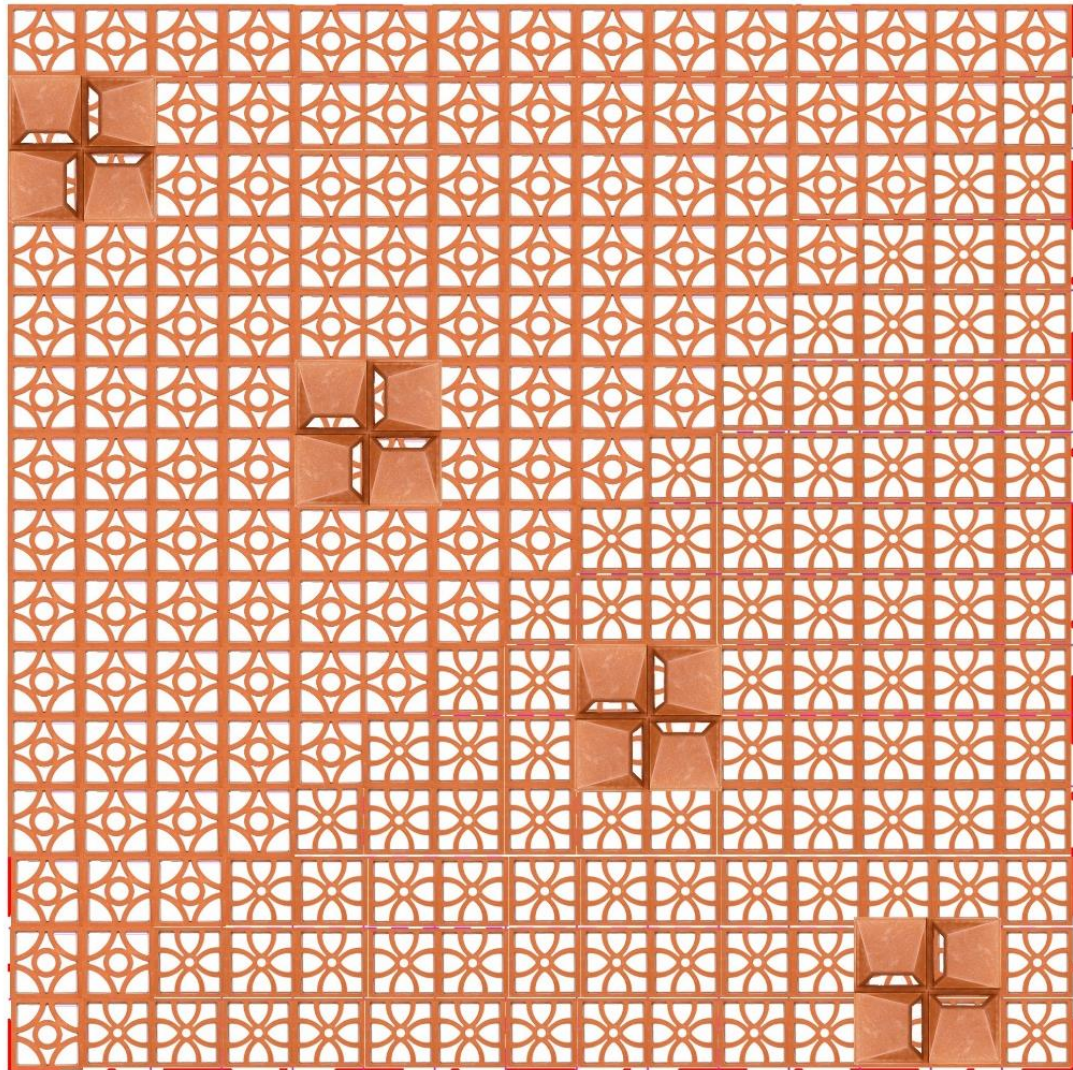


10' - 0"

JAALI DESIGN

DETAILING

10' - 0"

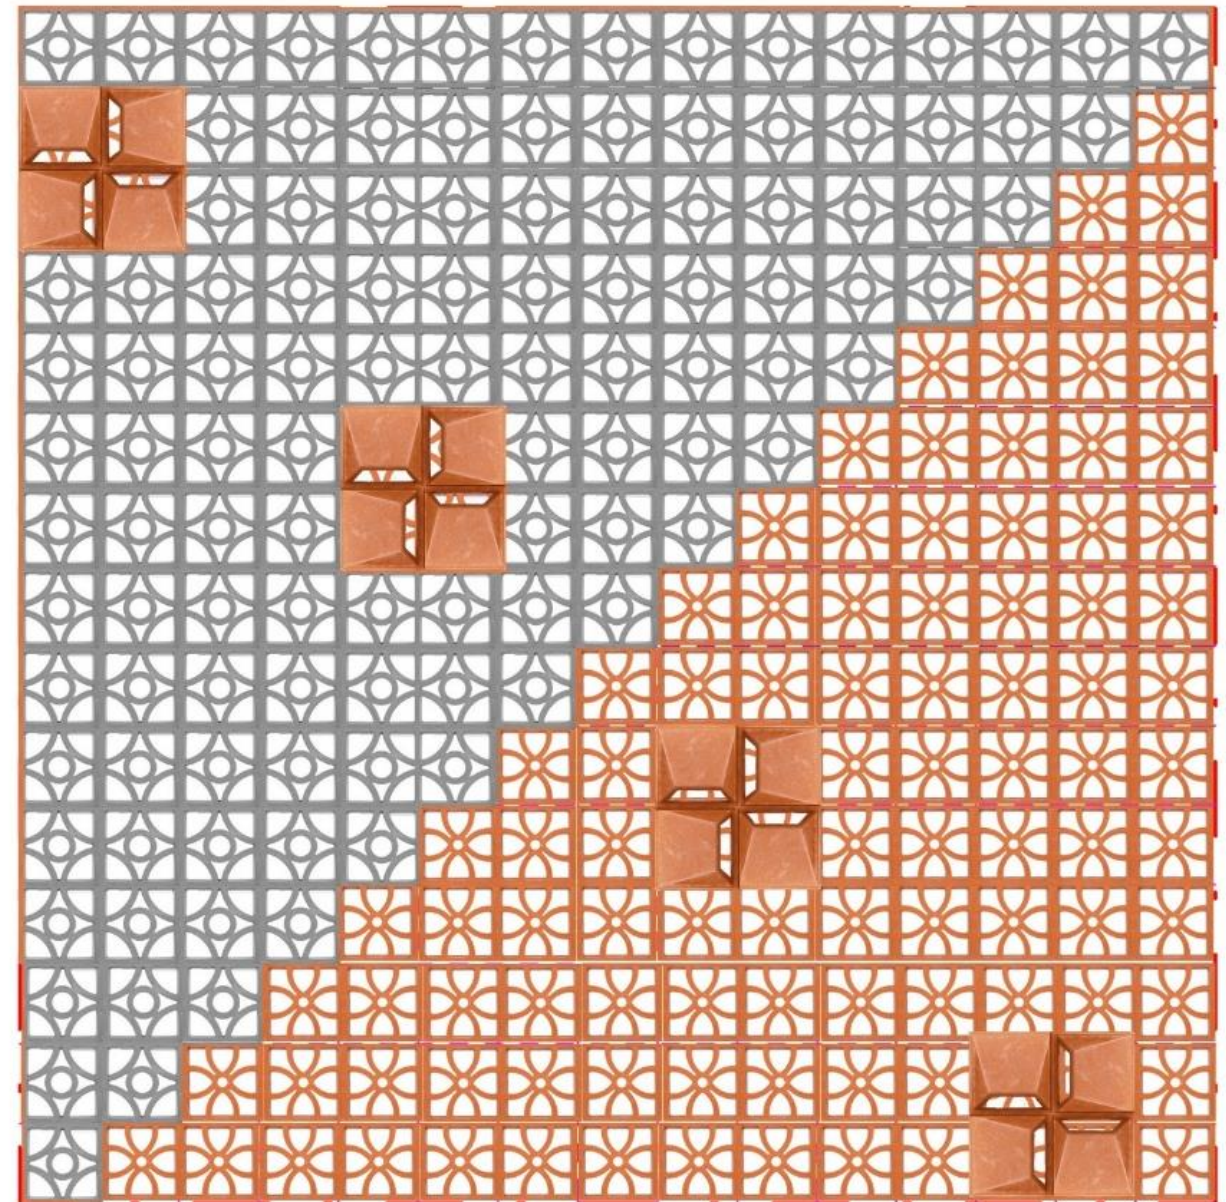

10' - 0"

ARCHITECTURE | CONSTRUCTION | INTERIOR | MANAGEMENT | BIM | DIGITAL

www.pcdesigns.in | 7845223384



PC designs
Architecture & Construction

MATERIAL VISUALIZATION
RENDERED MODEL





PC designs
Architecture & Construction

06 KODI VILLA

CLIENT - Mr KODISWARAN
TYPOLOGY - RESIDENCE
LOCATION - THENI
SCOPE - RENOVATION
AREA - 2000 Sqft







PC designs
Architecture & Construction

FACADE DESIGN

PROJECTING STEEL PERGOLA

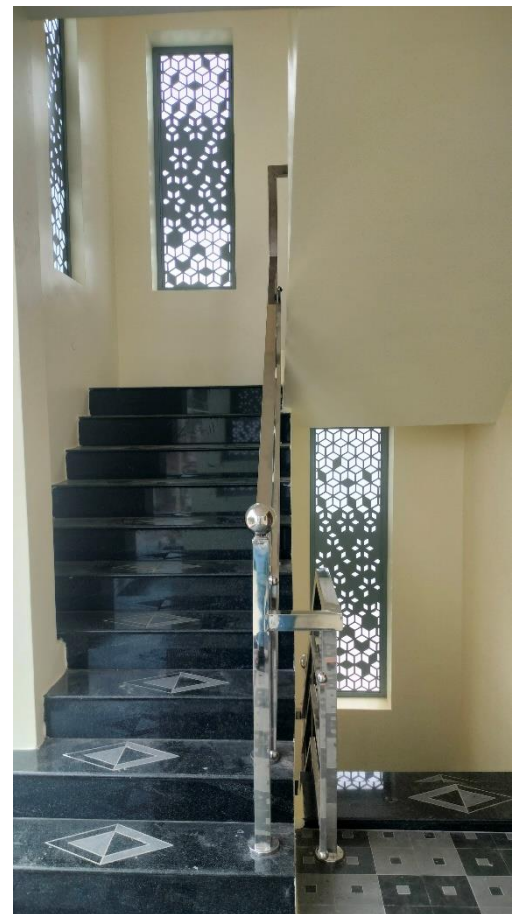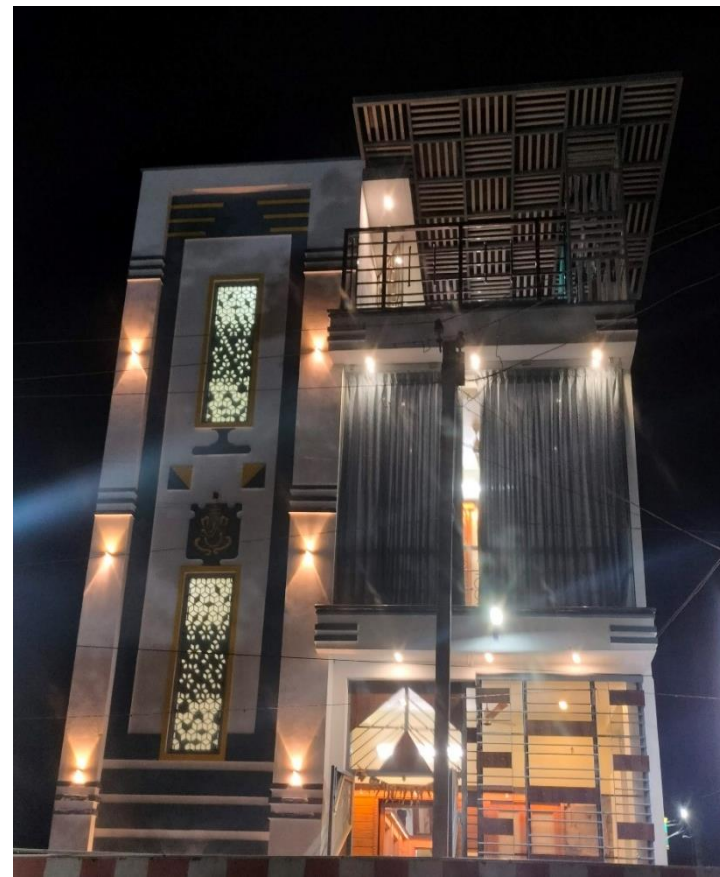

CNC GRILL DESIGN




PC designs
Architecture & Construction





07 ABIRAMAN VILLA

CLIENT - Mr ABIRAMAN
TYPOLOGY - RESIDENCE
LOCATION - THENI
SCOPE - RENOVATION
AREA - 3000 Sqft



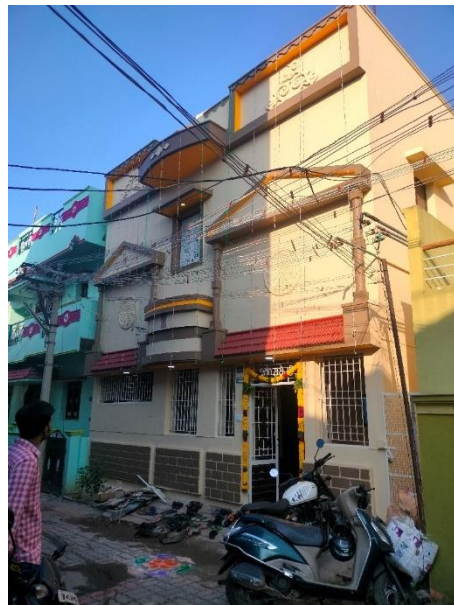

PC designs
Architecture & Construction

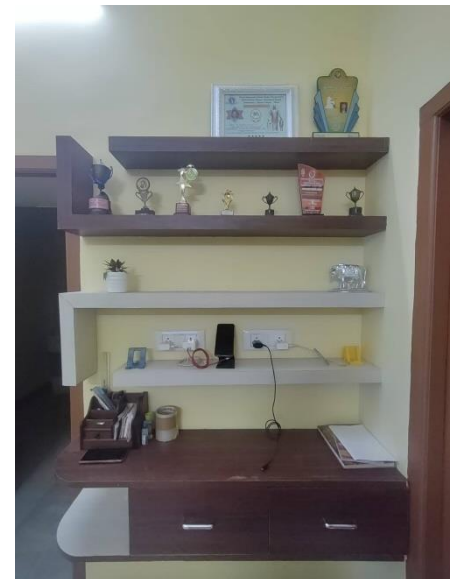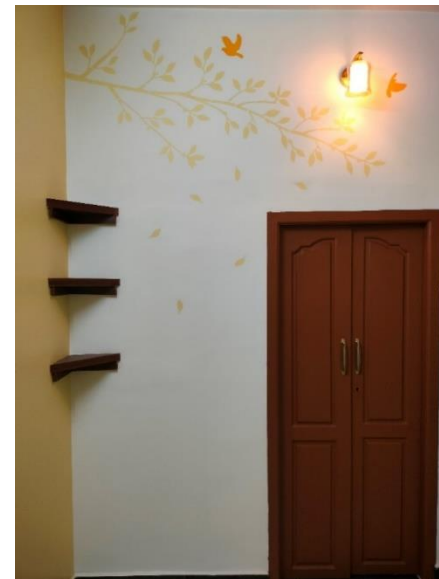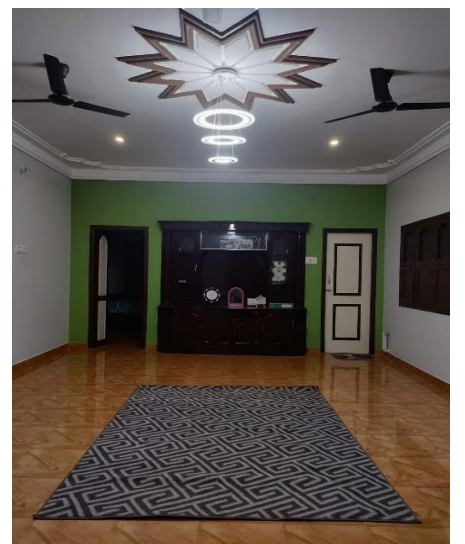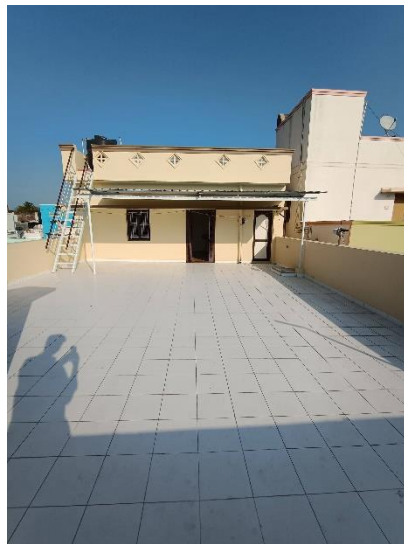

ARCHITECTURE | CONSTRUCTION | INTERIOR | MANAGEMENT | BIM | DIGITAL
www.pcdesigns.in | 7845223384



PC designs
Architecture & Construction



CELEBRATION
House Warming



08 BRICK NEST



CLIENT - Mr SAKTHI
TYPOLOGY - RESIDENCE
LOCATION - THENI
SCOPE - DESIGN
AREA - 1000 Sqft

ARCHITECTURE | CONSTRUCTION | INTERIOR | MANAGEMENT | BIM | DIGITAL

www.pcdesigns.in | 7845223384





PC designs
Architecture & Construction

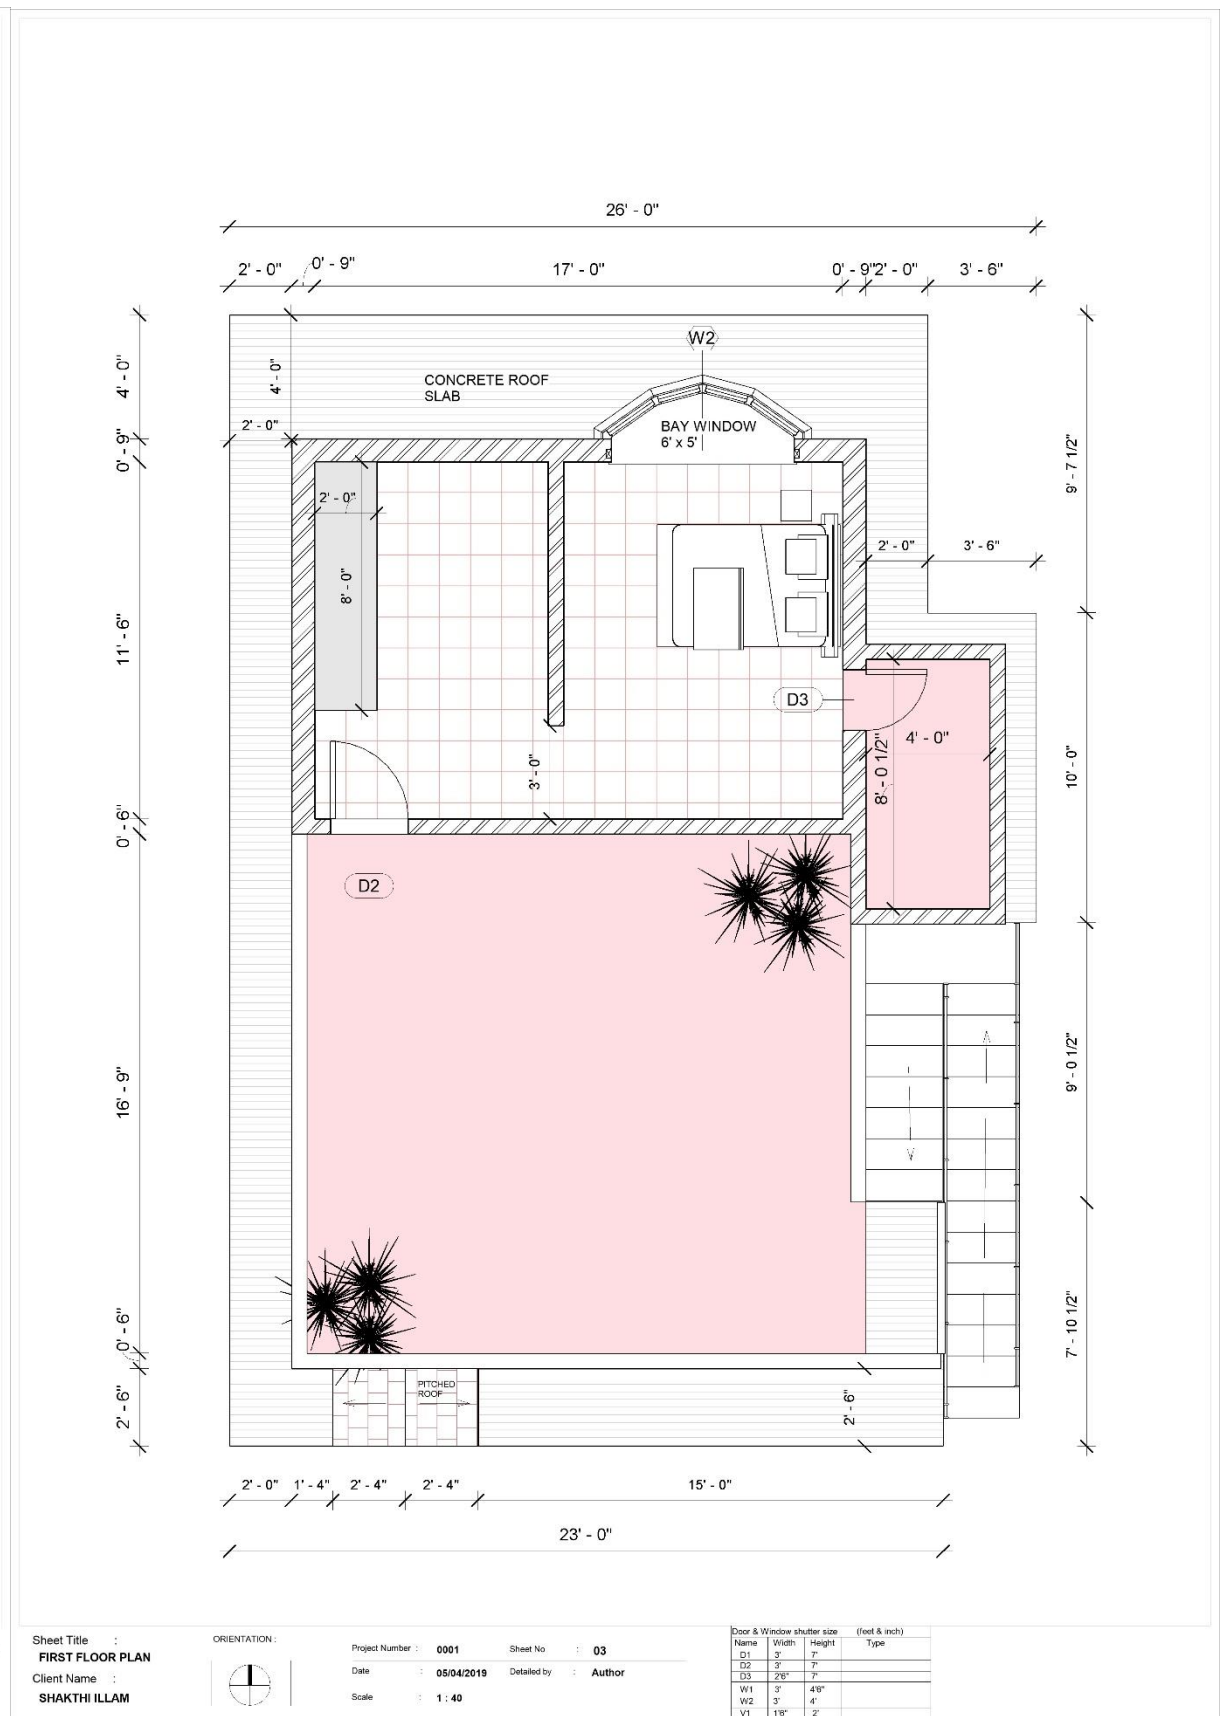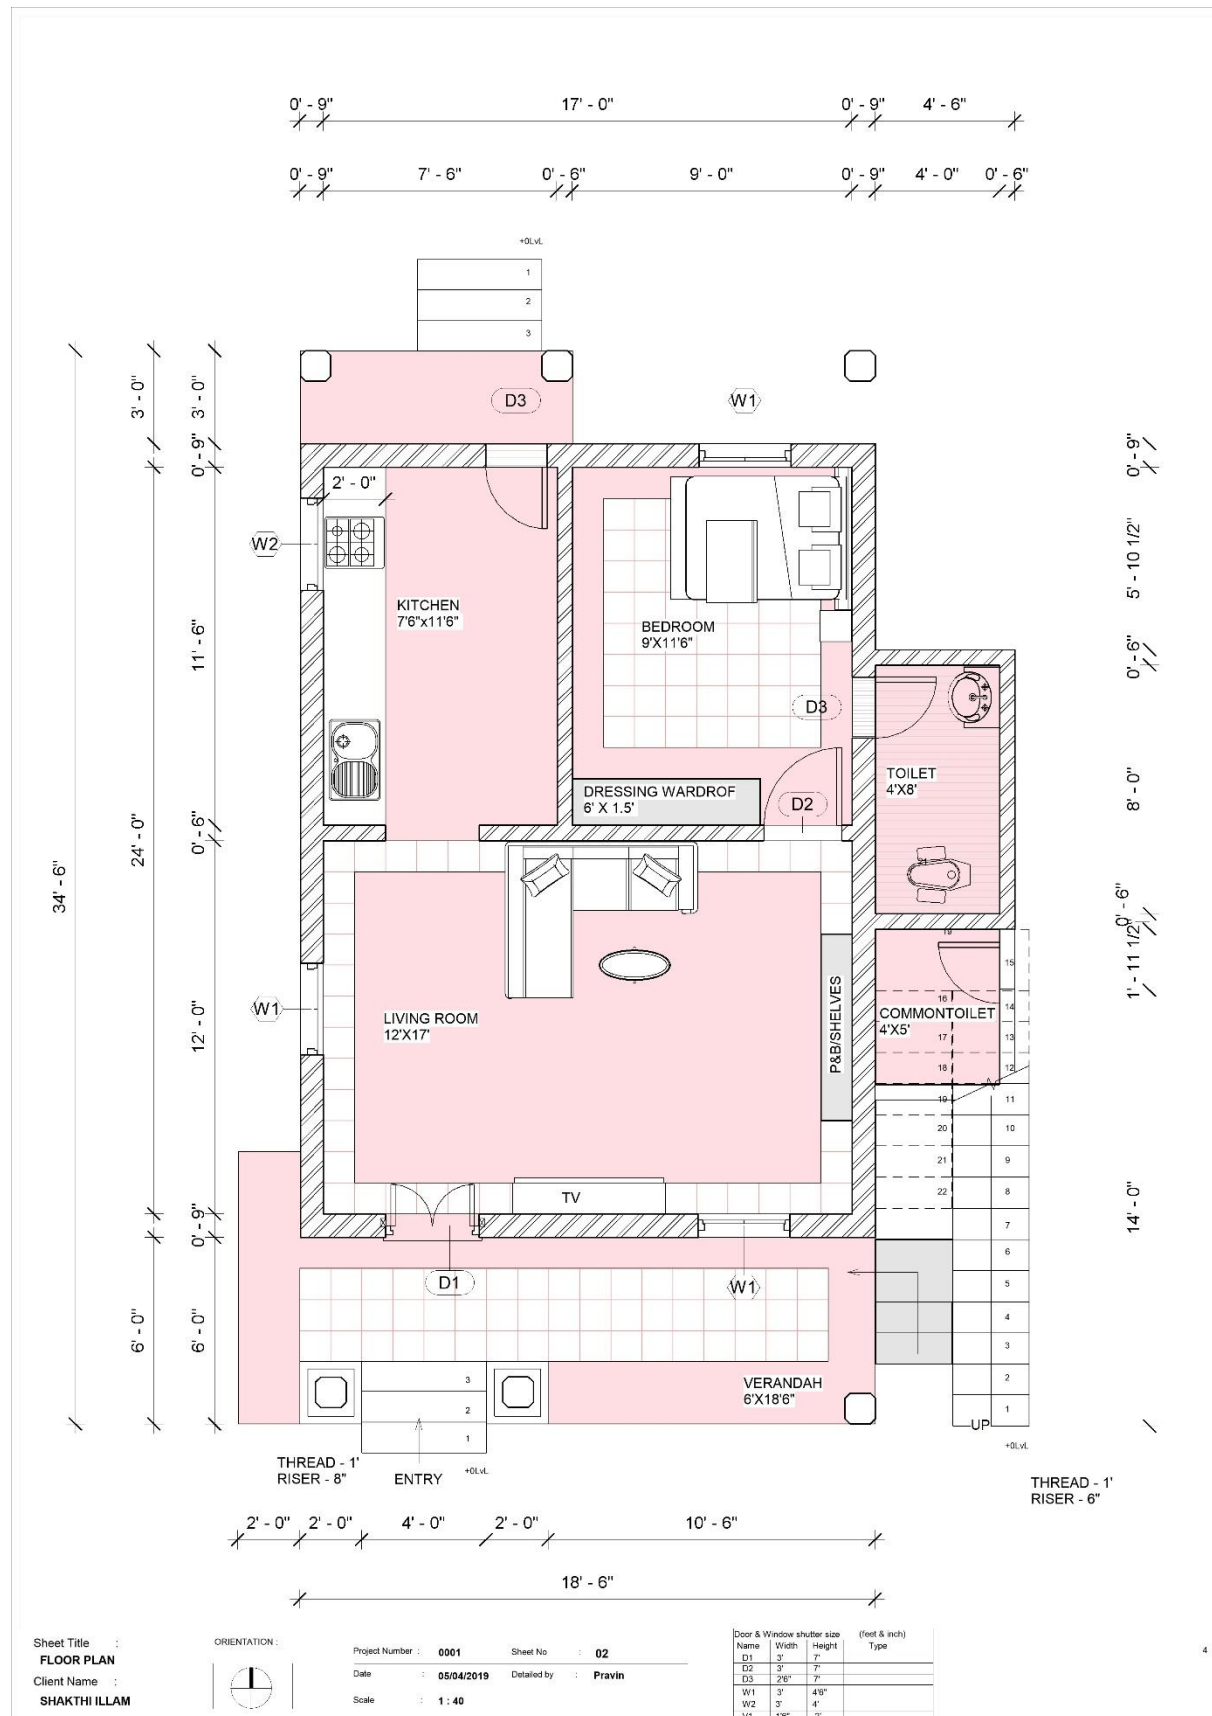





PC designs
Architecture & Construction

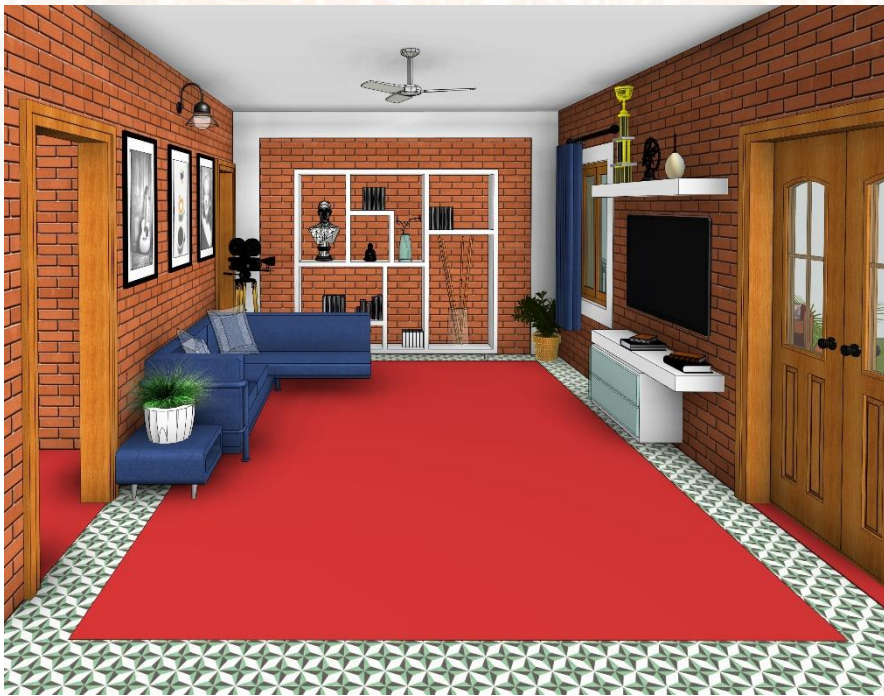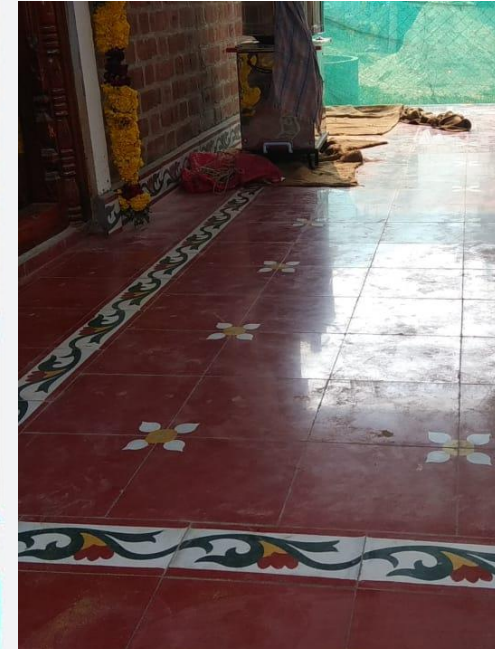



PC designs
Architecture & Construction

09 Proposed elevation for Omesh Villa @ Erode





PC designs
Architecture & Construction



Proposed elevation for Omesh Villa @ Erode

ARCHITECTURE | CONSTRUCTION | INTERIOR | MANAGEMENT | BIM | DIGITAL
www.pcdesigns.in | 7845223384



PC designs
Architecture & Construction



ARCHITECTURE | CONSTRUCTION | INTERIOR | MANAGEMENT | BIM | DIGITAL
www.pcdesigns.in | 7845223384



PC designs
Architecture & Construction



Proposed elevation for Guhan Villa @ Erode

ARCHITECTURE | CONSTRUCTION | INTERIOR | MANAGEMENT | BIM | DIGITAL
www.pcdesigns.in | 7845223384



PC designs
Architecture & Construction

SITE PHOTO



10 RAJARAM VILLA

CLIENT - Mr RAJARAM
TYPOLOGY - RESIDENCE
LOCATION - THENI
SCOPE - RENOVATION
AREA - 1950 Sqft





ARCHITECTURE | CONSTRUCTION | INTERIOR | MANAGEMENT | BIM | DIGITAL

www.pcdesigns.in | 7845223384





PC designs
Architecture & Construction

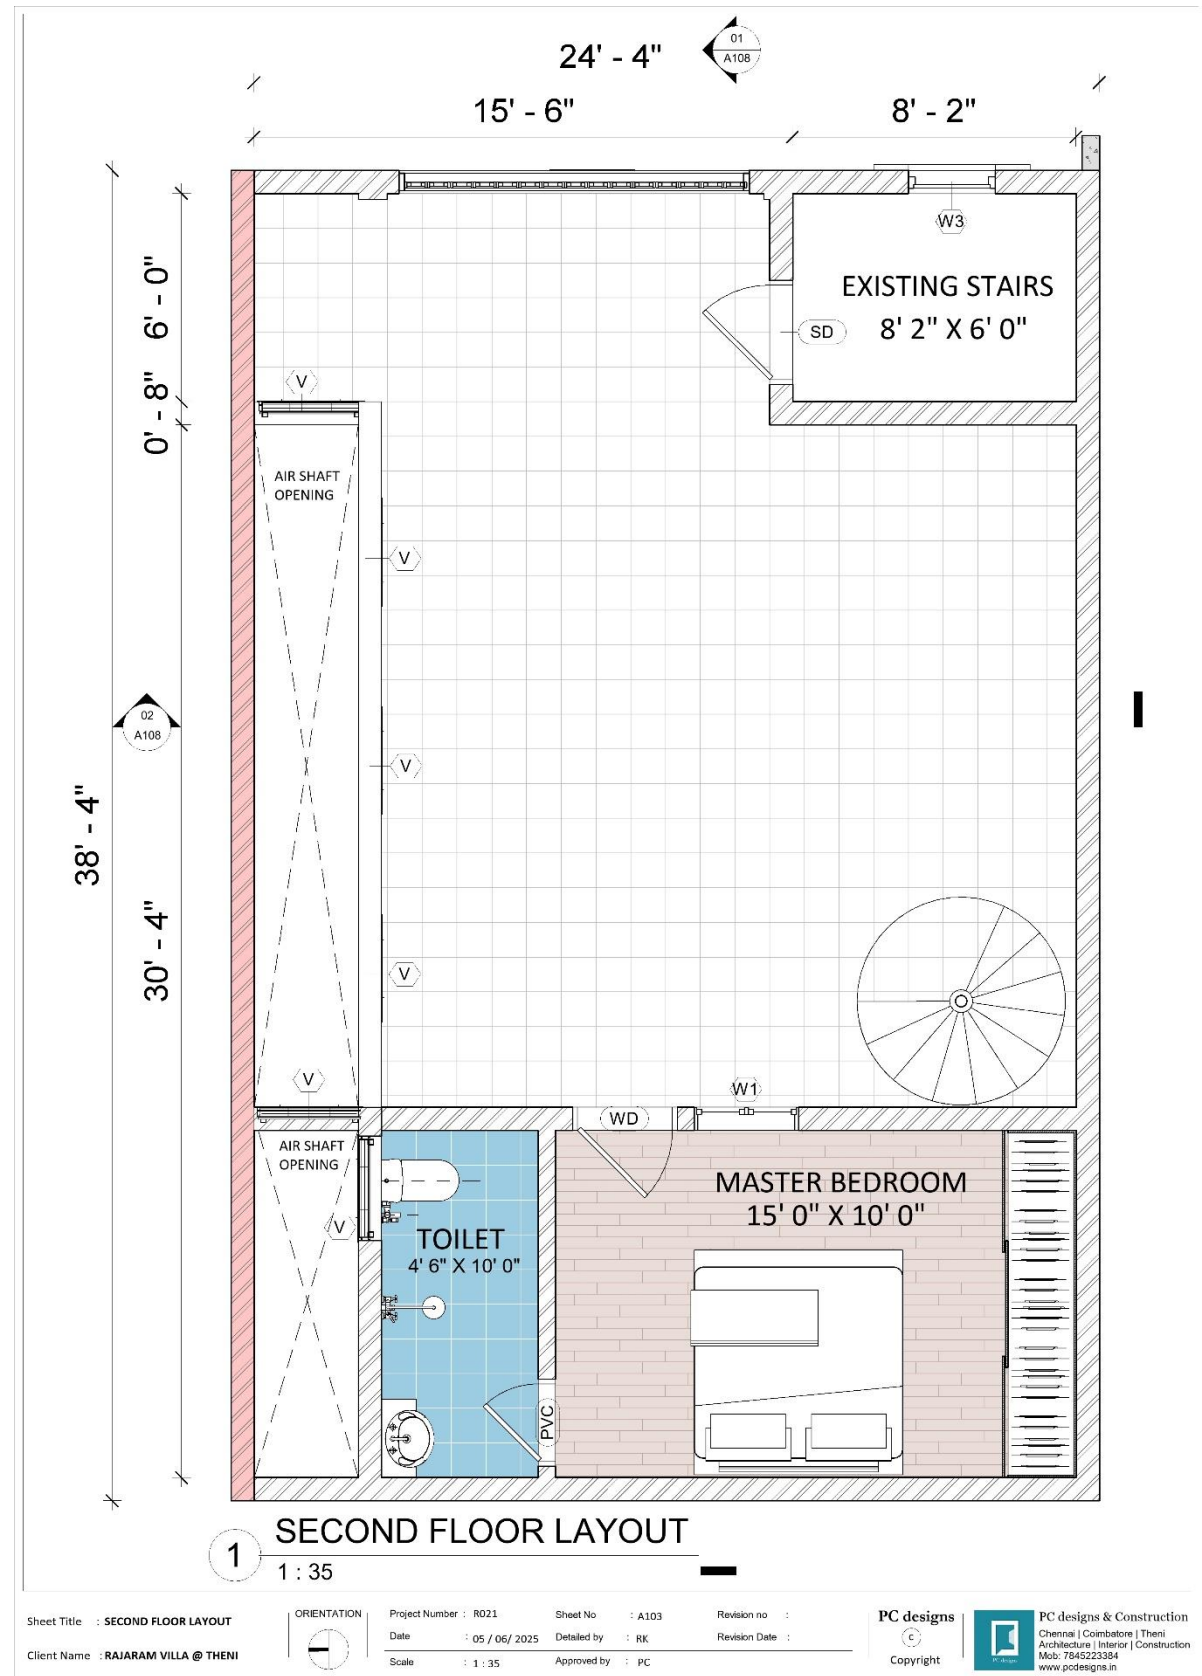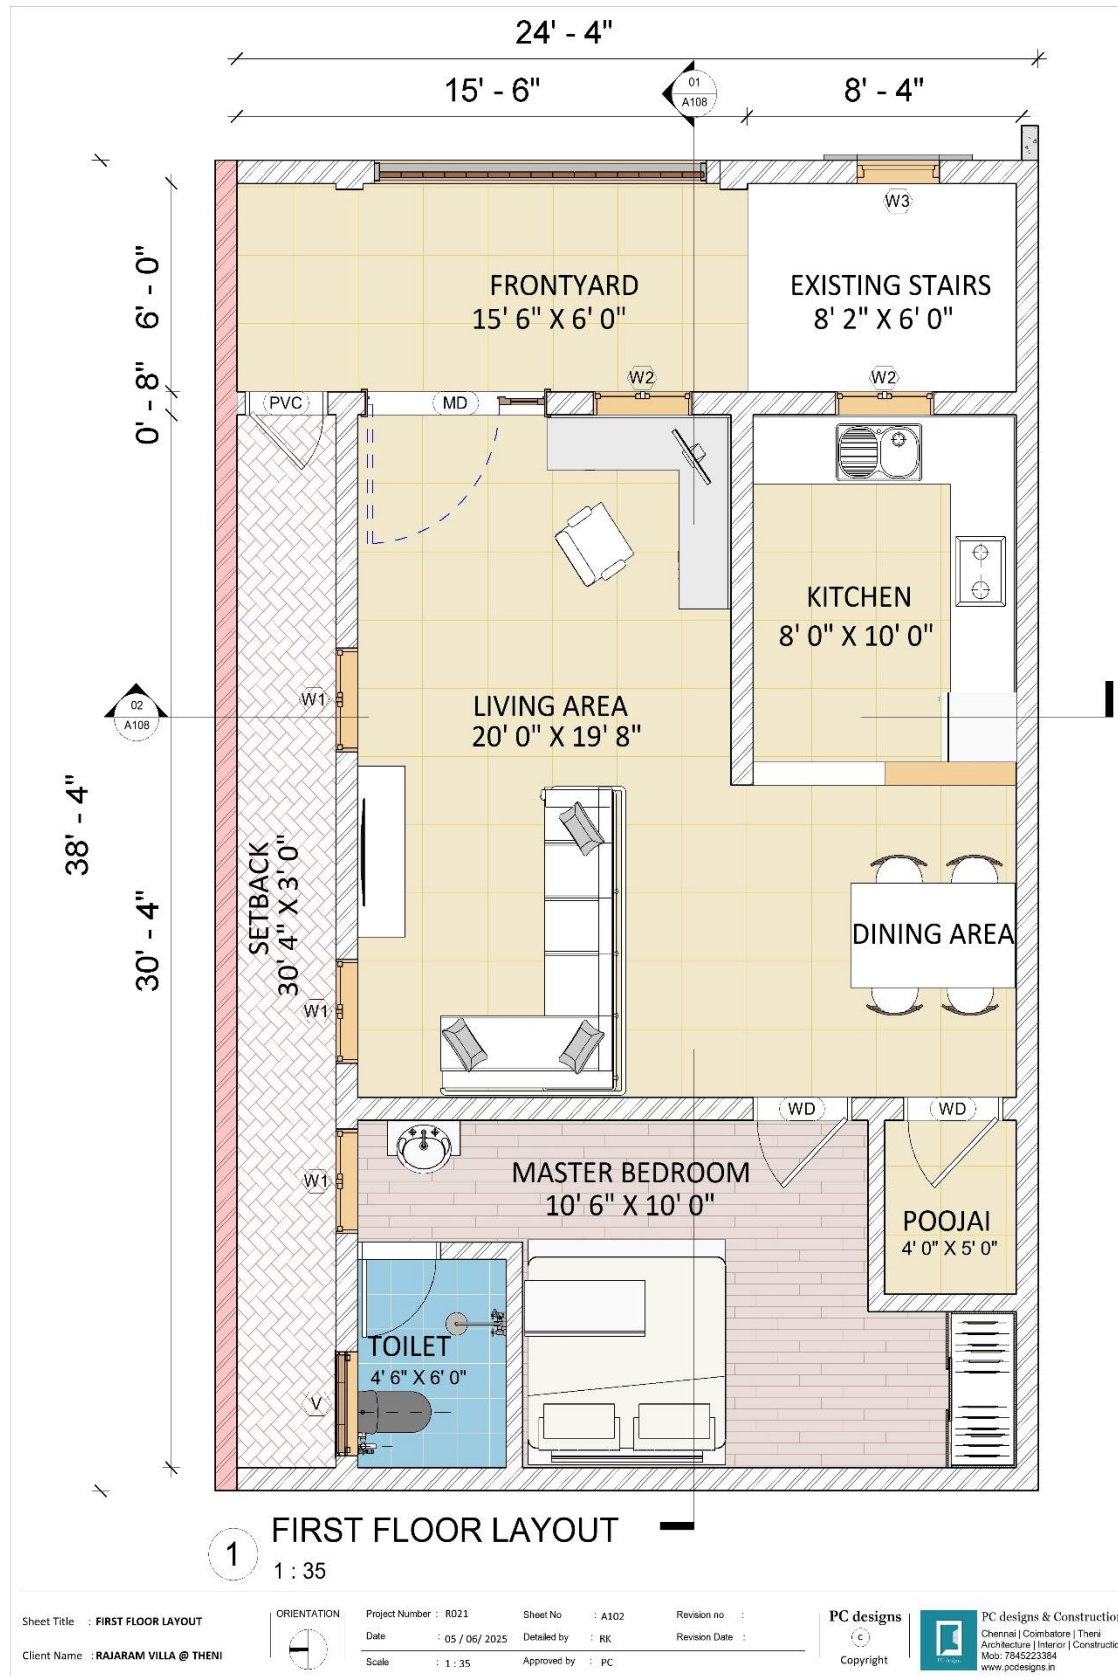




PC designs
Architecture & Construction

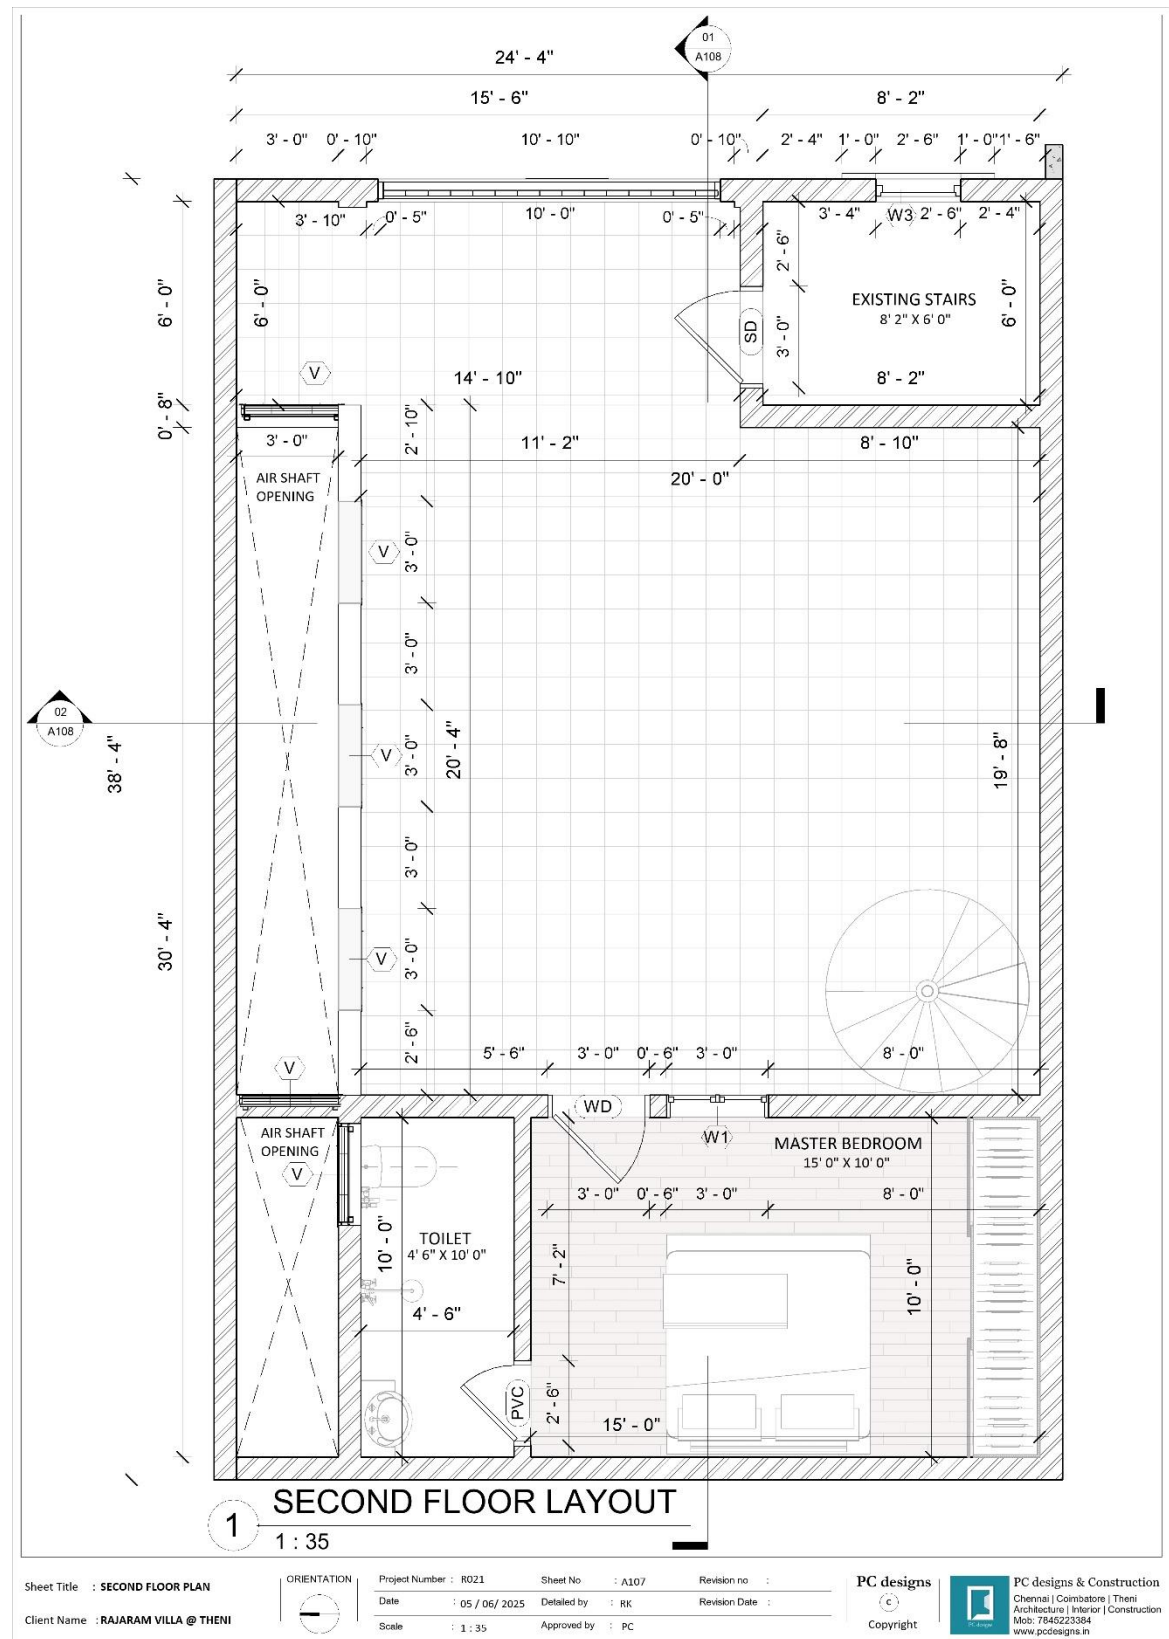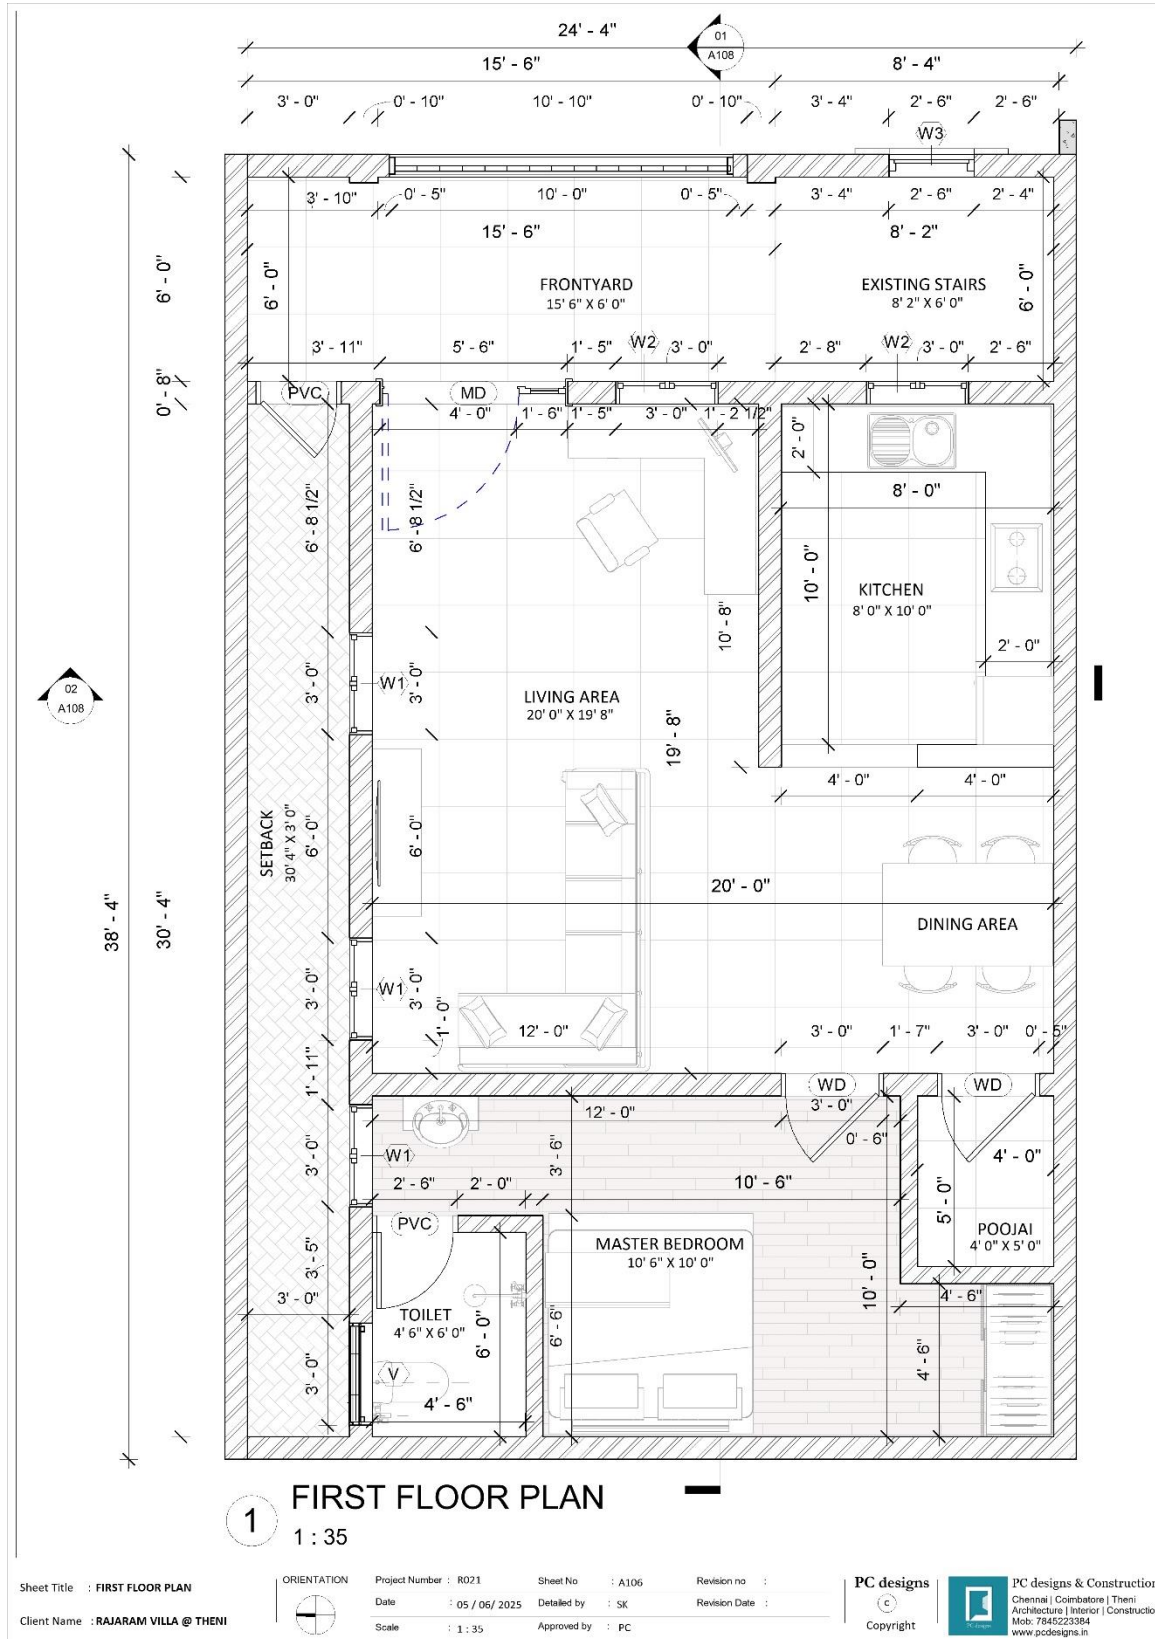




PC designs
Architecture & Construction

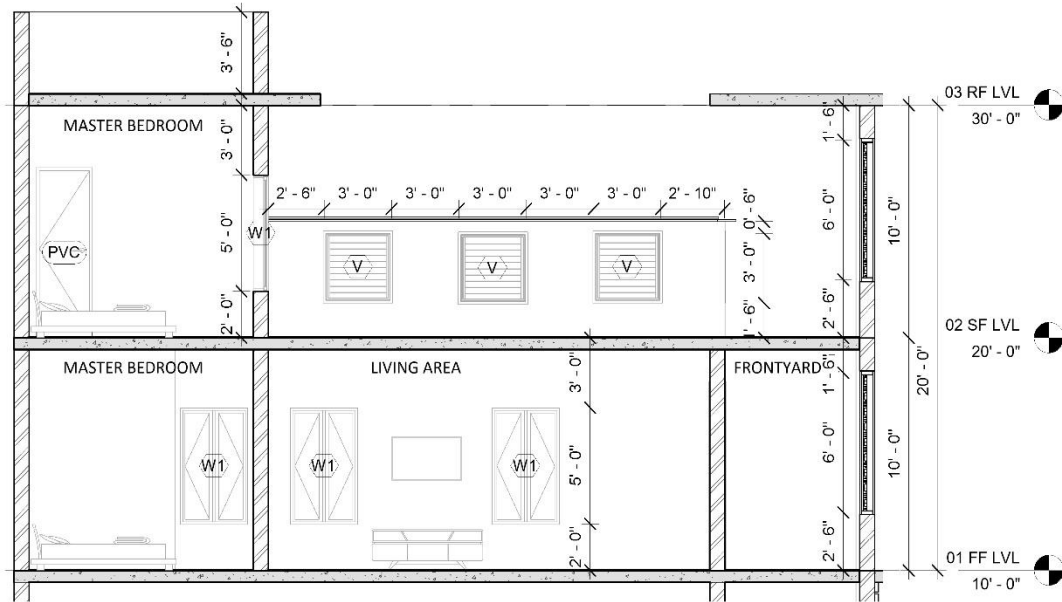

01 SECTION 01
1 : 50

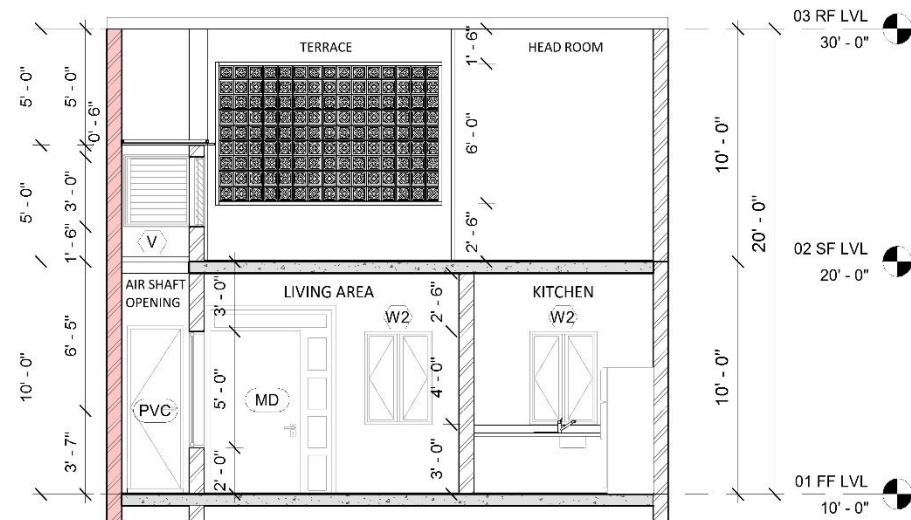

02 SECTION 02
1 : 50

Sheet Title : SECTION
Client Name : RAJARAM VILLA @ THENI




Project Number : R021
Date : 05 / 06 / 2025
Scale : 1 : 50
Sheet No : A108
Detailed by : RK
Approved by : PC
Revision no :
Revision Date :

PC designs
Copyright



PC designs & Construction
Chennai | Coimbatore | Theni
Architecture | Interior | Construction
Mob: 7845223384
www.pcdesigns.in

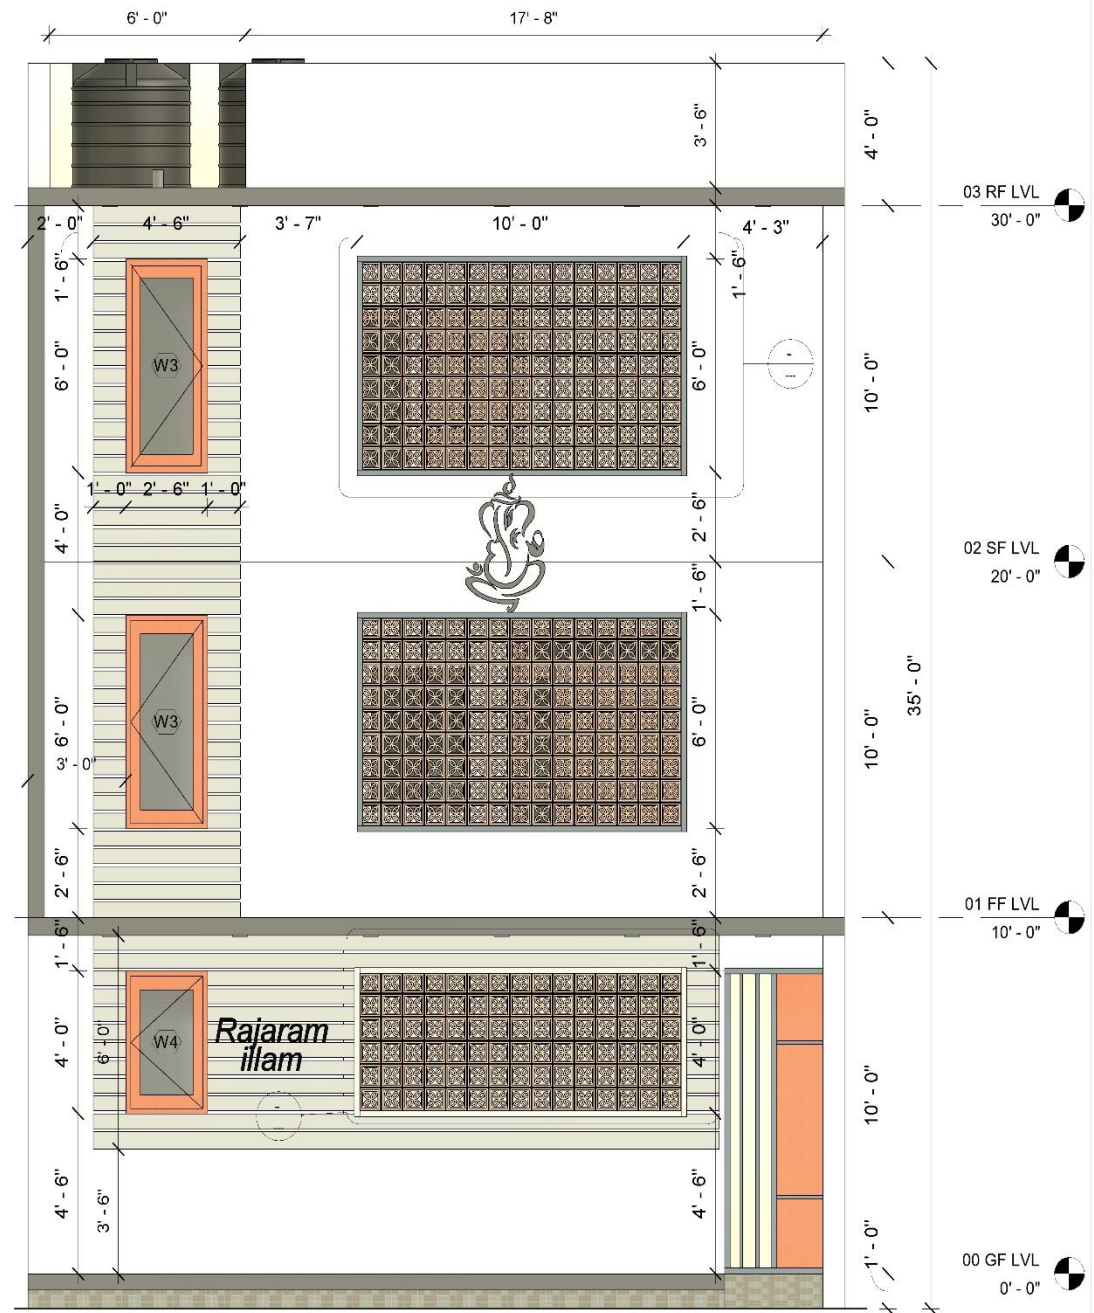

1 FRONT ELEVATION
1 : 35

Sheet Title : ELEVATION
Client Name : RAJARAM VILLA @ THENI



Project Number : R021
Date : 05 / 06 / 2025
Scale : 1 : 35
Sheet No : A109
Detailed by : Author
Approved by : Checker
Revision no :
Revision Date :

PC designs
Copyright



PC designs & Construction
Chennai | Coimbatore | Theni
Architecture | Interior | Construction
Mob: 7845223384
www.pcdesigns.in



PC designs
Architecture & Construction



1 3D View 01



2 3D View 02

Sheet Title : 3D VIEWS
Client Name : RAJARAM VILLA @ THENI




Project Number : R021
Date : 05 / 06 / 2025
Scale :
Sheet No : A105
Detailed by : RK
Approved by : PC
Revision no :
Revision Date :


PC designs
Copyright



PC designs & Construction
Chennai | Coimbatore | Theni
Architecture | Interior | Construction
Mob: 7845223384
www.pcdesigns.in

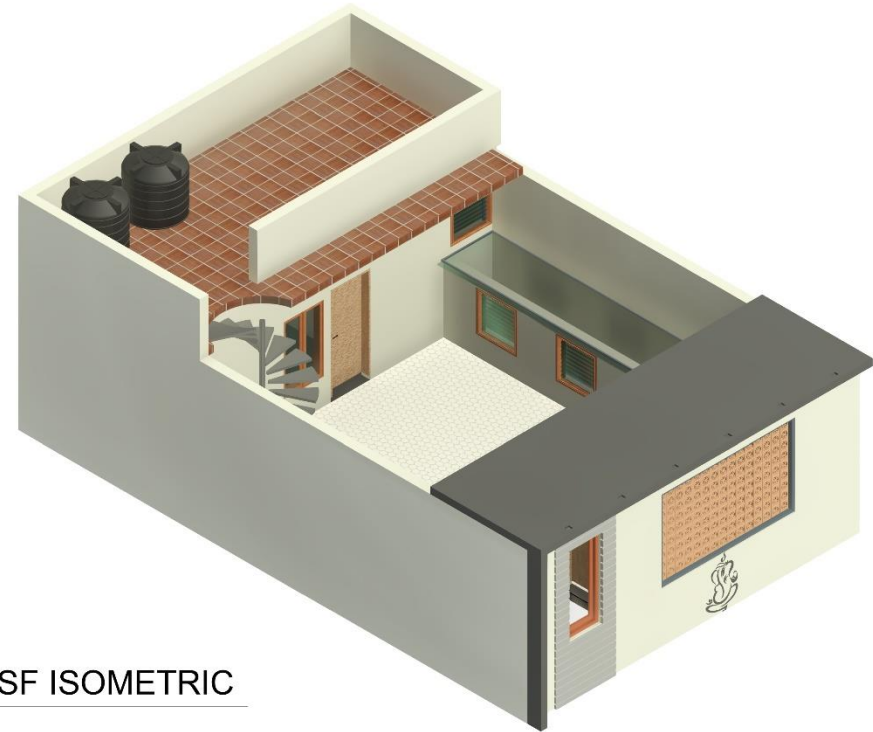

2 SF ISOMETRIC

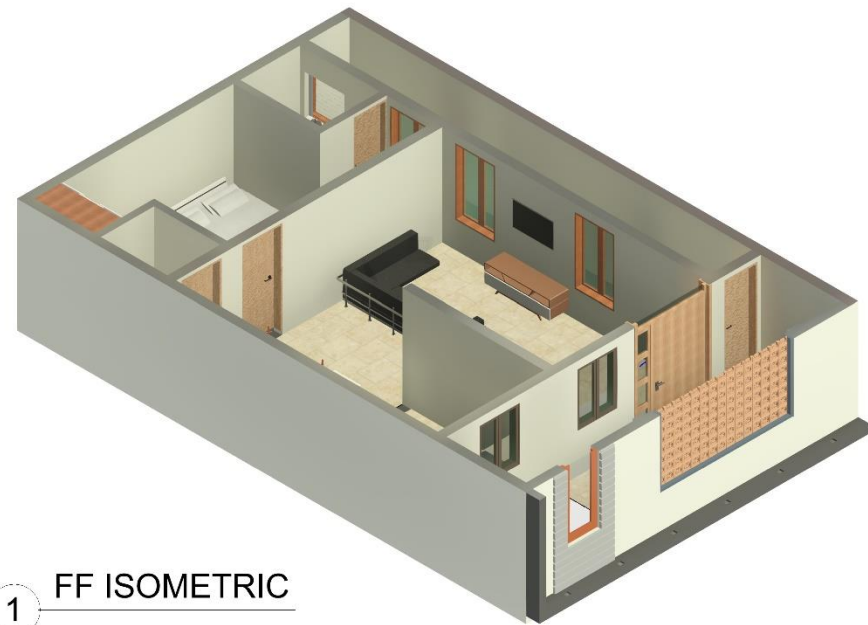

1 FF ISOMETRIC

Sheet Title : ISOMETRIC VIEW
Client Name : RAJARAM VILLA @ THENI



Project Number : R021
Date : 05 / 06 / 2025
Scale :
Sheet No : A113
Detailed by : SK
Approved by : PC
Revision no :
Revision Date :


PC designs
Copyright



PC designs & Construction
Chennai | Coimbatore | Theni
Architecture | Interior | Construction
Mob: 7845223384
www.pcdesigns.in




PC designs
Architecture & Construction

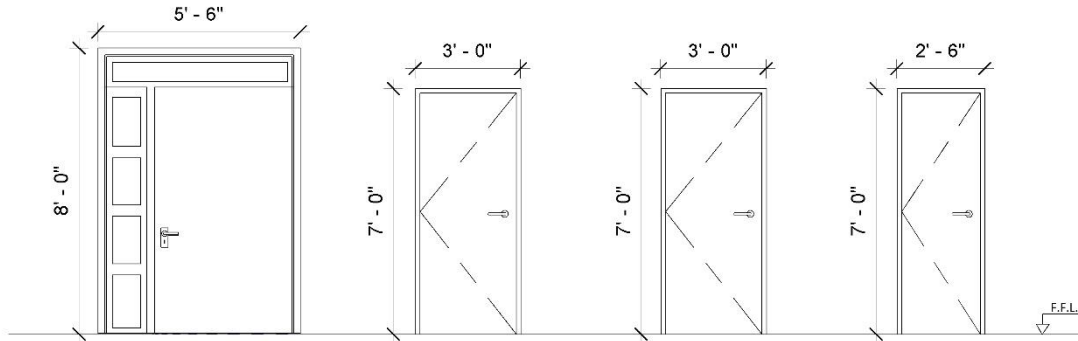

1 DOOR SCHEDULE

1 : 35



SCHEDULE OF DOOR				
DOOR TYPE	TAG	HEIGHT	WIDTH	COUNT
MAIN DOOR	MD	8' - 0"	5' - 6"	1
BEDROOM WOODEN DOOR	D1	7' - 0"	3' - 0"	3
METAL DOOR	SD	7' - 0"	3' - 0"	1
PVC_FLUSH DOOR	PVC	7' - 0"	2' - 6"	3
Grand total: 8				

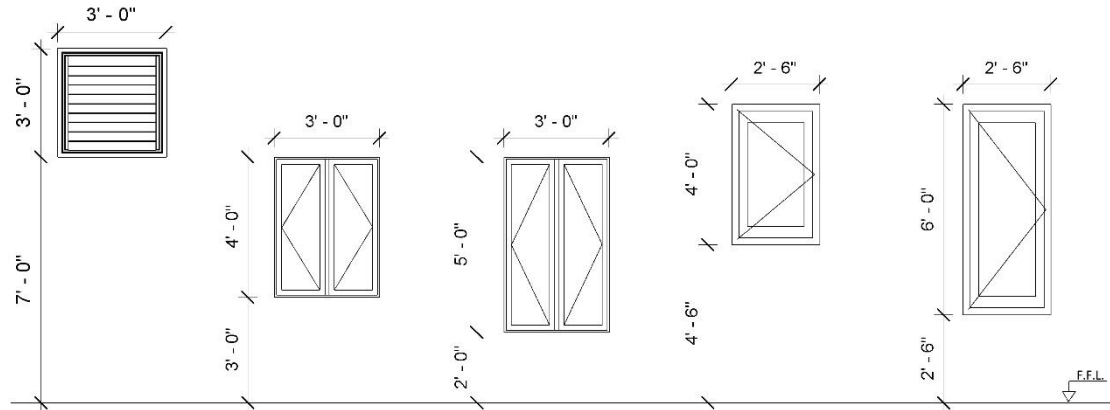

2 WINDOW SCHEDULE

1 : 35

SCDEHULE OF WINDOW				
WINDOW TYPE	TAG	HEIGHT	WIDTH	COUNT
VENTILATOR	V	3' - 0"	3' - 0"	7
DOUBLE SHUTTER 01	W2	4' - 0"	3' - 0"	2
SINGLE SHUTTER 01	W4	4' - 0"	2' - 6"	1
DOUBLE SHUTTER 02	W1	5' - 0"	3' - 0"	4
SINGLE SHUTTER - 02	W3	6' - 0"	2' - 6"	2
Grand total: 16				

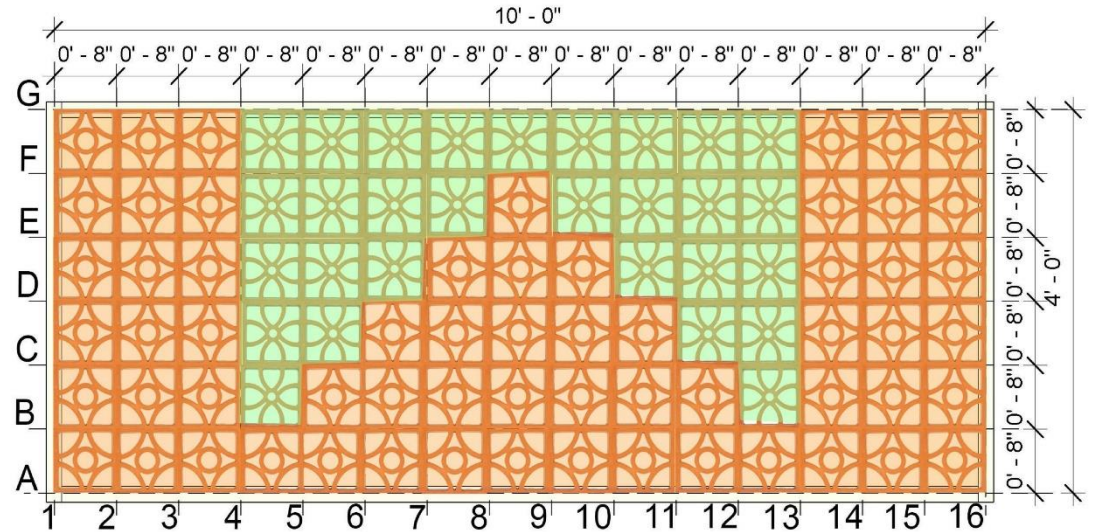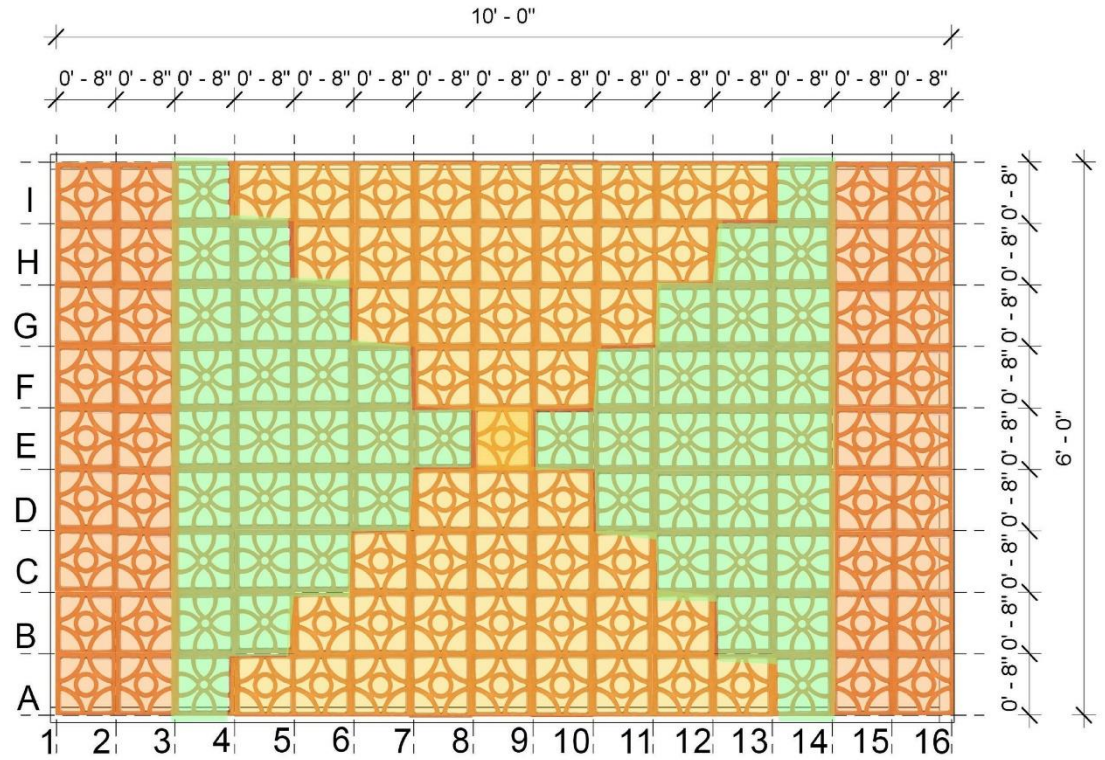

Sheet Title : SCHEDULE OF OPENING 01
Client Name : RAJARAM VILLA @ THENI



Project Number : R021
Date : 05 / 06 / 2025
Scale : 1 : 35
Sheet No : A111
Detailed by : SK
Approved by : PC
Revision no :
Revision Date :

PC designs
Copyright

PC designs & Construction
Chennai | Coimbatore | Theni
Architecture | Interior | Construction
Mob: 7845223384
www.pcdesigns.in

Sheet Title : SCHEDULE OF OPENING 02
Client Name : RAJARAM VILLA @ THENI



Project Number : R021
Date : 05 / 06 / 2025
Scale :
Sheet No : A112
Detailed by : SK
Approved by : PC
Revision no :
Revision Date :

PC designs
Copyright

PC designs & Construction
Chennai | Coimbatore | Theni
Architecture | Interior | Construction
Mob: 7845223384
www.pcdesigns.in